




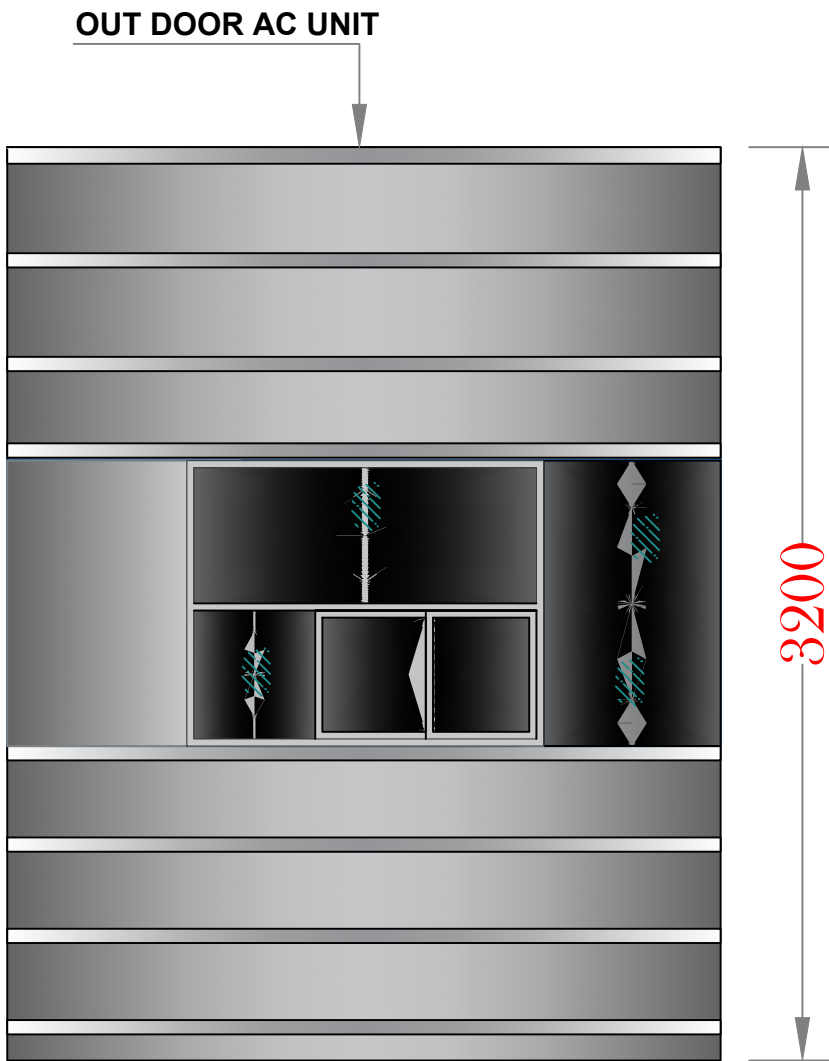


RIGHT ELEVATION

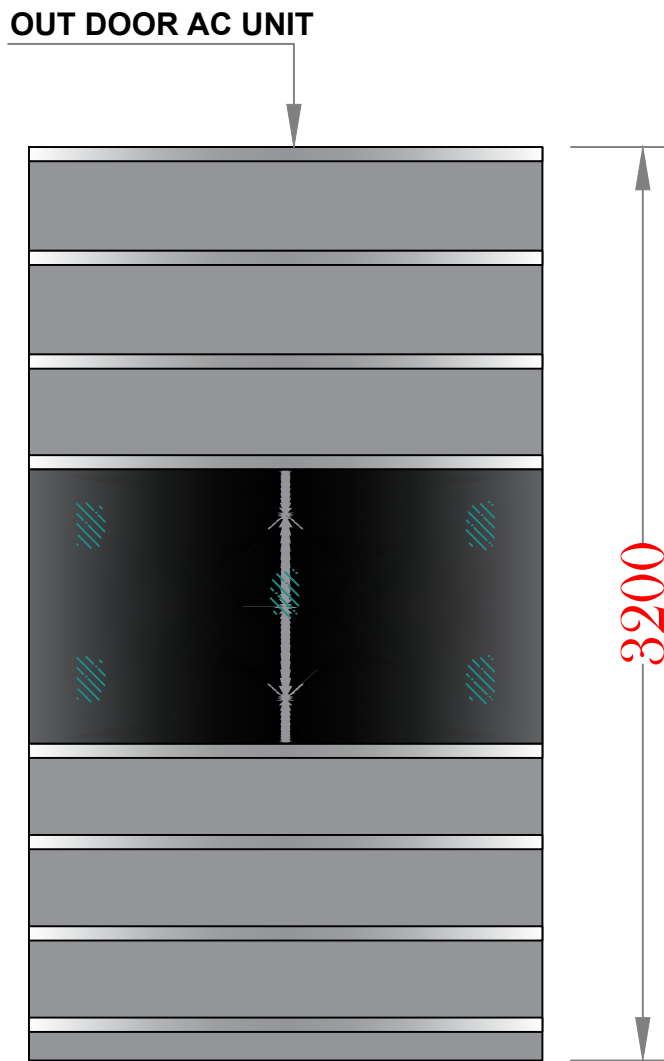


FRONT ELEVATION

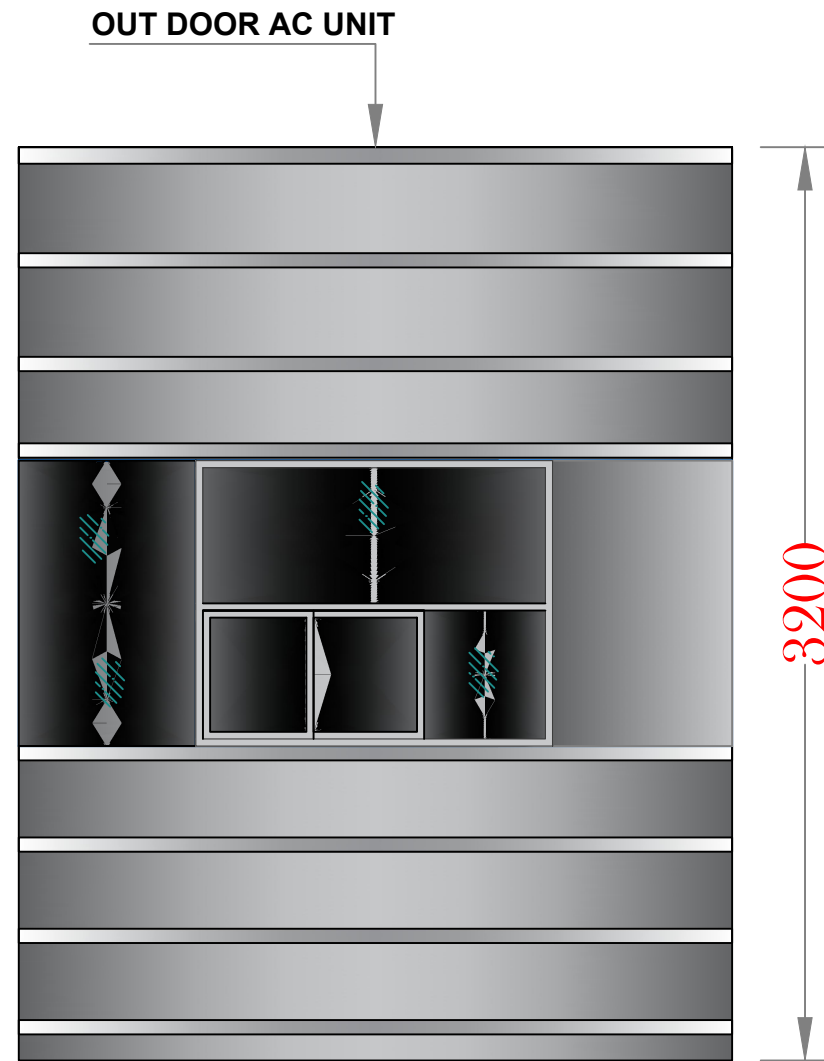

LEFT ELEVATION

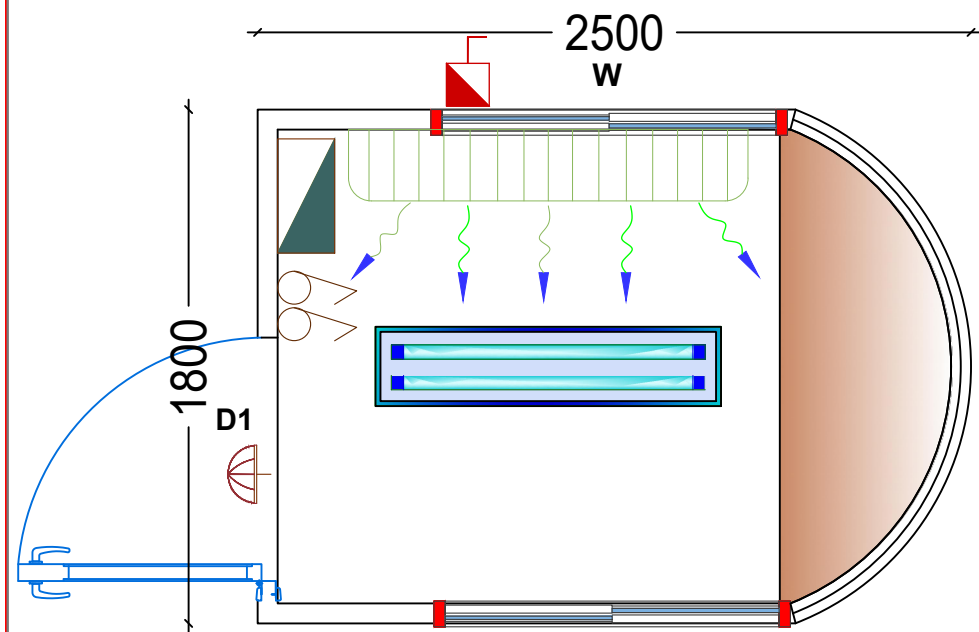

FLOOR PLAN

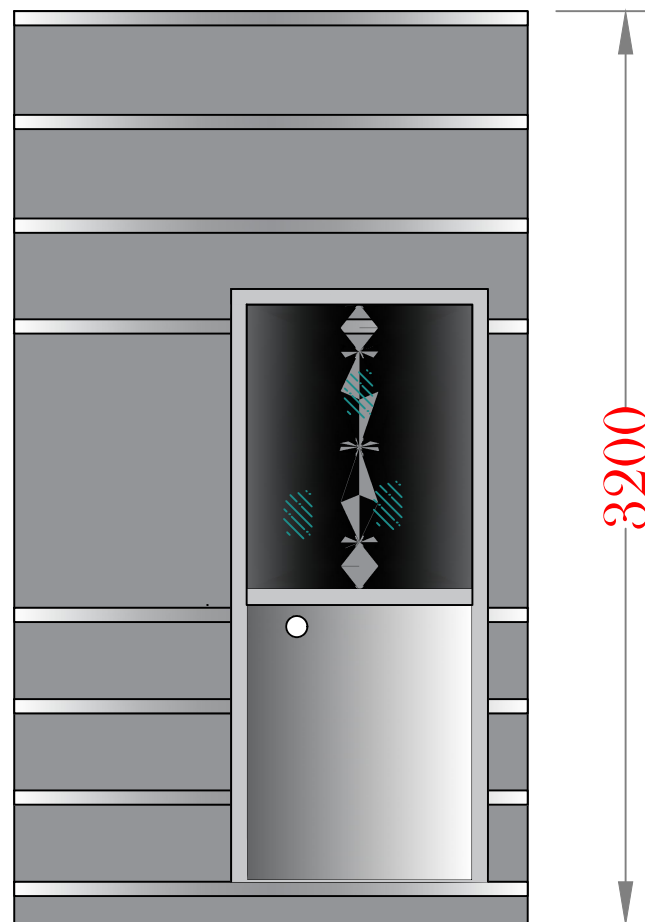

BACK ELEVATION

SCHEDULE OF DOOR AND WINDOW

DESCRIPTION	SYMBOL	SIZE
DOOR EXTERNAL FULL FRAME ALU. STEEL SANDWICH TYPE	D1	900X2100
SLIDING WINDOW	W	1250X1000

APPROVED
By Dirk Booysen at 3:00 pm, Apr 26, 2021

LEGEND

ELECTRICAL

	13A SWITCH SOCKET(Double)
	15A SWITCH SOCKET
	WATER HEATER 12 gl.
	ISOLATOR-32A (IP 65,TP/SP)
	DISTRIBUTION BOARD
	ONE GANG ONE WAY SWITCH
	DOUBLE POLE SWITCH NEON-20A
	DATA POINT (provision only)
	TEL. POINT (provision only)
	13A SWITCH SOCKET
	REF.FLUORESCENT FITTING-4x18w (60x60)
	FLUORESCENT FITTING-1x36w
	FLUORESCENT FITTING-2x36w
	BULKHEAD LAMP
	EXHAUST FAN (6")

PLUMBING

	W/C EUROPEAN		KITCHEN SINK
	W/C ASIAN		WATER HEATER
	WASH BASIN		FLOOR TRAP
	URINAL		WATER TAP
	SHOWER TRAY		

PREFAB
Space Box Prefab Houses Ind L.L.C
Tel: 06-5214409 Fax:06-5214409
Mob: 050-4738366
Email:arif@prefabuae.com
www.prefabuae.com

APPROVED BY CLIENT

GREEN BRANCH
CONTACTING

APPROVED BY: DESIGNER
ASIF LATIF

APPROVED BY: PRODUCTION MANAGER
MR. SALIM

DWG. NO. - FLOOR : Nos.
G.F ONLY


DRAWING TITLE : SECURITY CABIN

SHEET CONTENTS FLOOR & ELEVATION DETAIL AREA


DATE: 14-04-2021 PROJECT PHASE :

REV:	DESCRIPTION	DATE

Location	SCALE : NTS	SHEET NO:
DRAWN BY AL	PAPER SIZE : A3	01

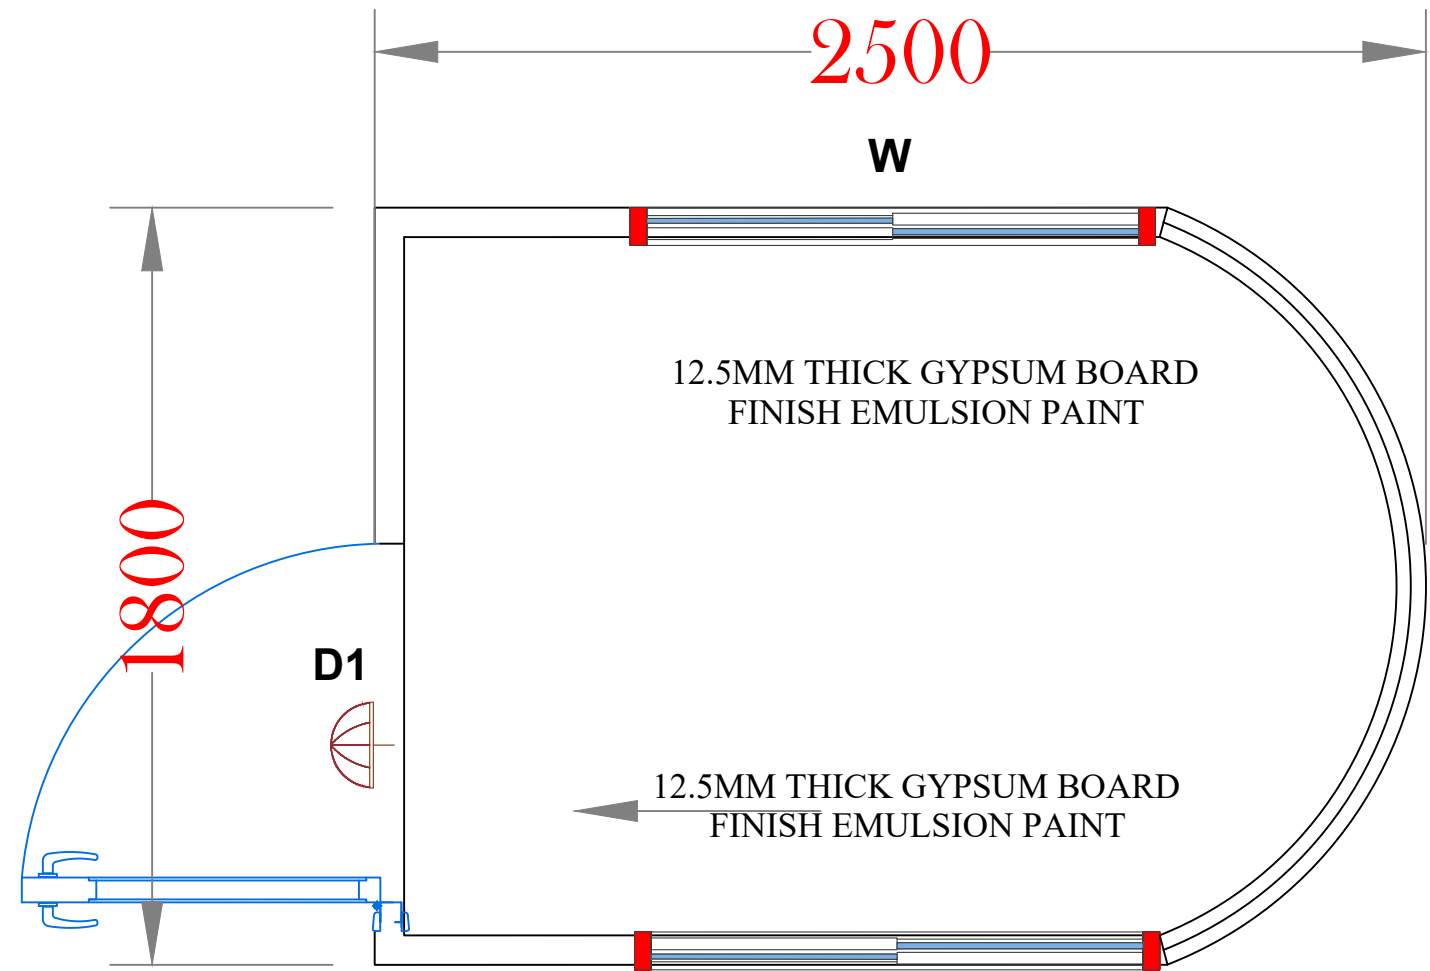

CEILING PLAN

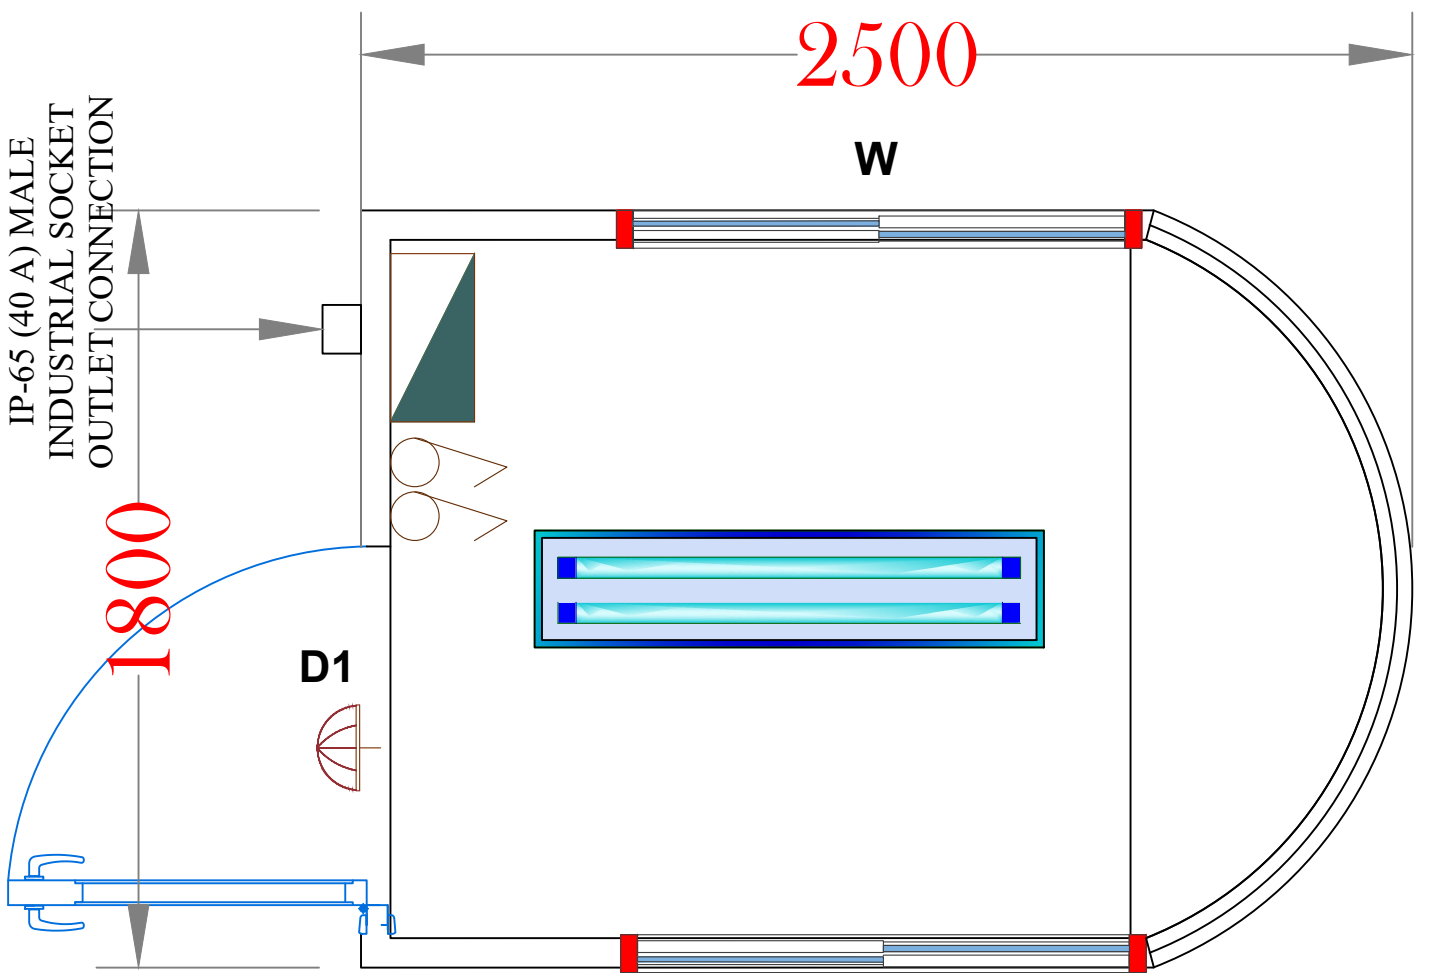

LIGHTING PLAN

APPROVED
By Dirk Booysen at 3:00 pm, Apr 26, 2021


LEGEND

ELECTRICAL

	13A SWITCH SOCKET(Double)
	15A SWITCH SOCKET
	WATER HEATER 12 gl.
	ISOLATOR-32A (IP 65,TP/SP)
	DISTRIBUTION BOARD
	ONE GANG ONE WAY SWITCH
	DOUBLE POLE SWITCH NEON-20A
	DATA POINT (provision only)
	TEL. POINT (provision only)
	13A SWITCH SOCKET
	REF.FLUORESCENT FITTING-4x18w (60x60)
	FLUORESCENT FITTING-1x36w
	FLUORESCENT FITTING-2x36w
	BULKHEAD LAMP
	EXHAUST FAN (6")

PLUMBING

	W/C EUROPEAN		KITCHEN SINK
	W/C ASIAN		WATER HEATER
	WASH BASIN		FLOOR TRAP
	URINAL		WATER TAP
	SHOWER TRAY		

 **PREFAB**

Space Box Prefab Houses Ind L.L.C
Tel: 06-5214409 Fax:06-5214409
Mob: 050-4738366
Email:arif@prefabuae.com
www.prefabuae.com

APPROVED BY CLIENT

**GREEN BRANCH
CONTACTING**

APPROVED BY: DESIGNER
ASIF LATIF

APPROVED BY: PRODUCTION MANAGER
MR. SALIM

DWG. NO. - FLOOR . Nos.
G.F ONLY


DRAWING TITLE :
SECURITY CABIN

SHEET CONTENTS LIGHTING & CEILING PLAN AREA


DATE: 14-04-2021 PROJECT PHASE :

REV.	DESCRIPTION	DATE

Location	SCALE : NTS	SHEET NO:
DRAWN BY AL	PAPER SIZE : A3	01

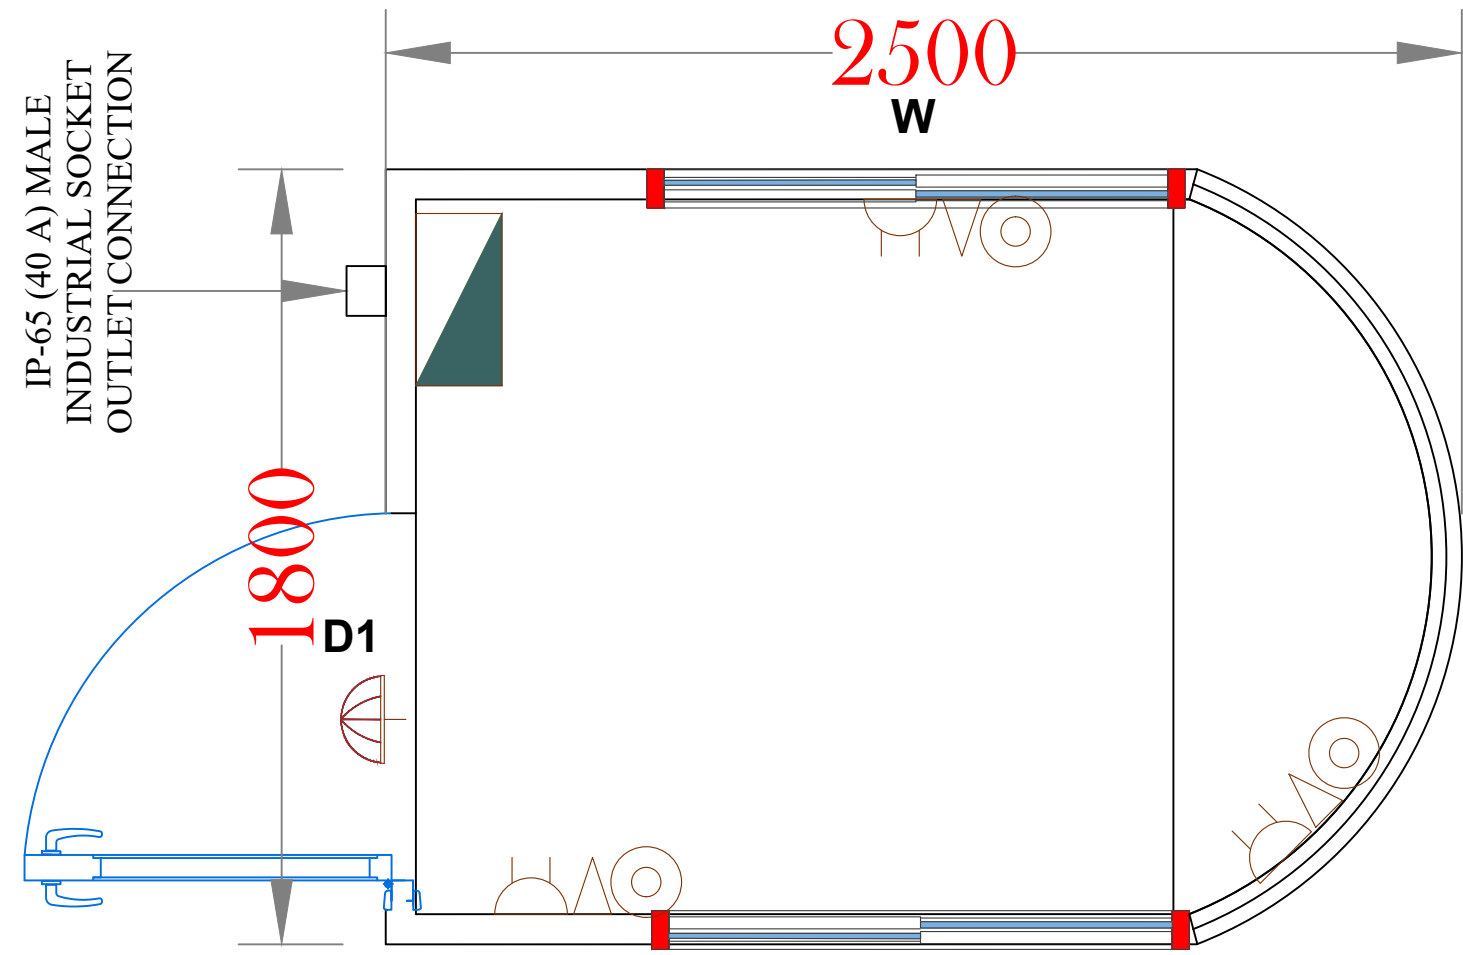

POWER PLAN

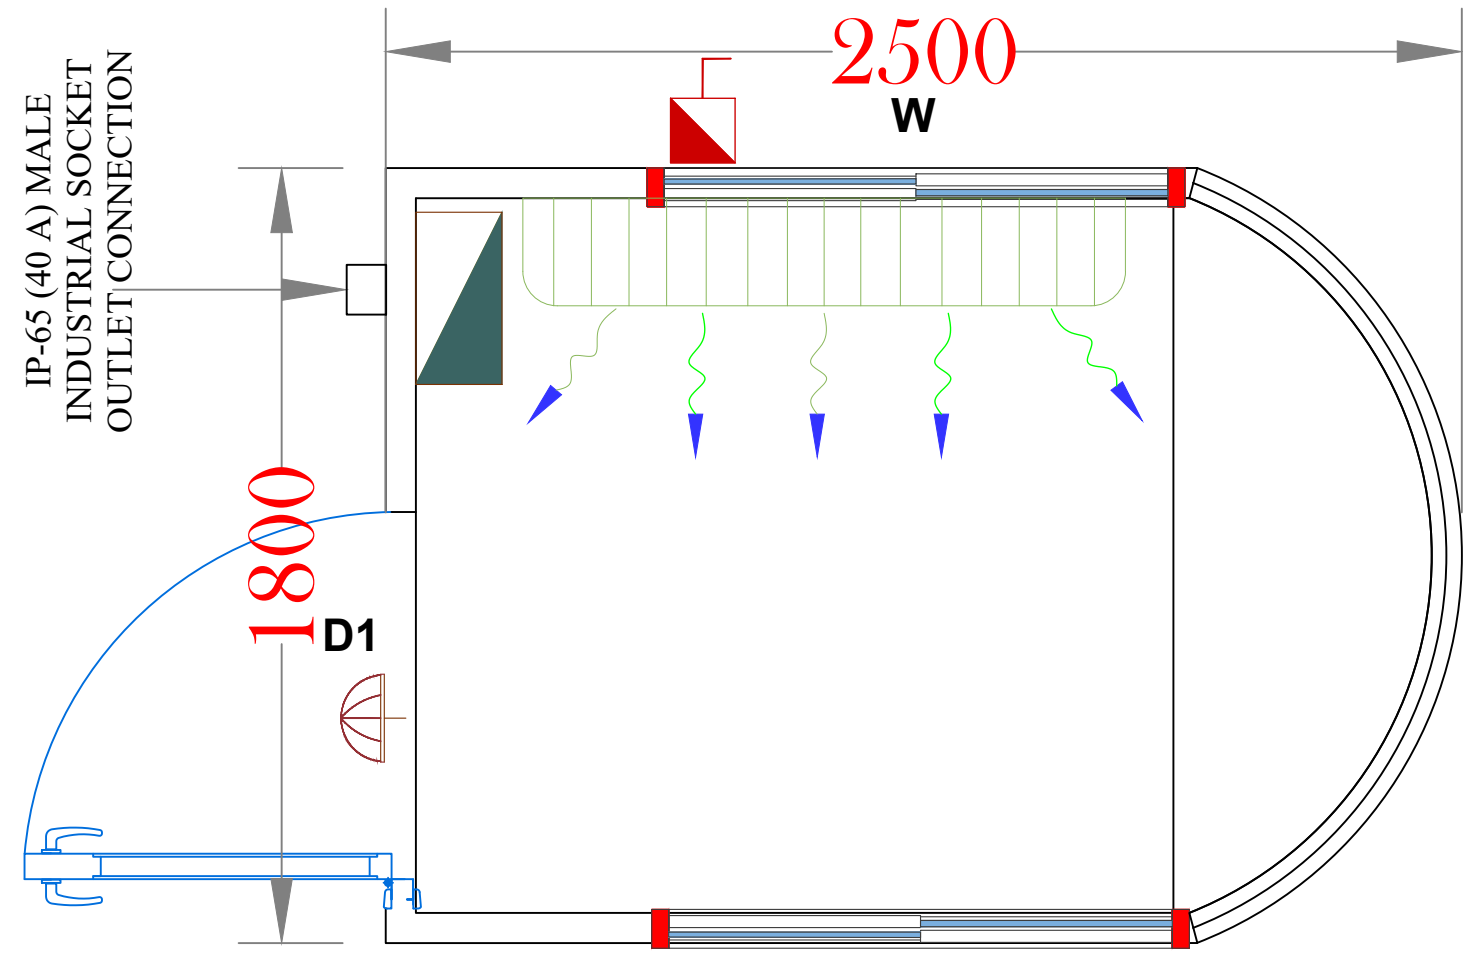


AC LAYOUT

APPROVED
By Dirk Booysen at 3:00 pm, Apr 26, 2021

LEGEND

ELECTRICAL	
	13A SWITCH SOCKET(Double)
	15A SWITCH SOCKET
	WATER HEATER 12 gl.
	ISOLATOR-32A (IP 65,TP/SP)
	DISTRIBUTION BOARD
	ONE GANG ONE WAY SWITCH
	DOUBLE POLE SWITCH NEON-20A
	DATA POINT (provision only)
	TEL. POINT (provision only)
	13A SWITCH SOCKET
	REF.FLUORESCENT FITTING-4x18w (60x60)
	FLUORESCENT FITTING-1x36w
	FLUORESCENT FITTING-2x36w
	BULKHEAD LAMP
	EXHAUST FAN (6")

PLUMBING			
	W/C EUROPEAN		KITCHEN SINK
	W/C ASIAN		WATER HEATER
	WASH BASIN		FLOOR TRAP
	URINAL		WATER TAP
	SHOWER TRAY		

 **PREFAB**

Space Box Prefab Houses Ind L.L.C
Tel: 06-5214409 Fax:06-5214409
Mob: 050-4738366
Email:arif@prefabuae.com
www.prefabuae.com

APPROVED BY CLIENT
**GREEN BRANCH
CONTACTING**

APPROVED BY: DESIGNER
ASIF LATIF

APPROVED BY: PRODUCTION MANAGER
MR. SALIM

DWG. NO. - FLOOR : Nos.
G.F ONLY


DRAWING TITLE : **SECURITY CABIN**

SHEET CONTENTS POWER & AC LAYOUT AREA


DATE: **14-04-2021** PROJECT PHASE :

REV:	DESCRIPTION	DATE

Location	SCALE : NTS	SHEET NO:
DRAWN BY AL	PAPER SIZE : A3	01

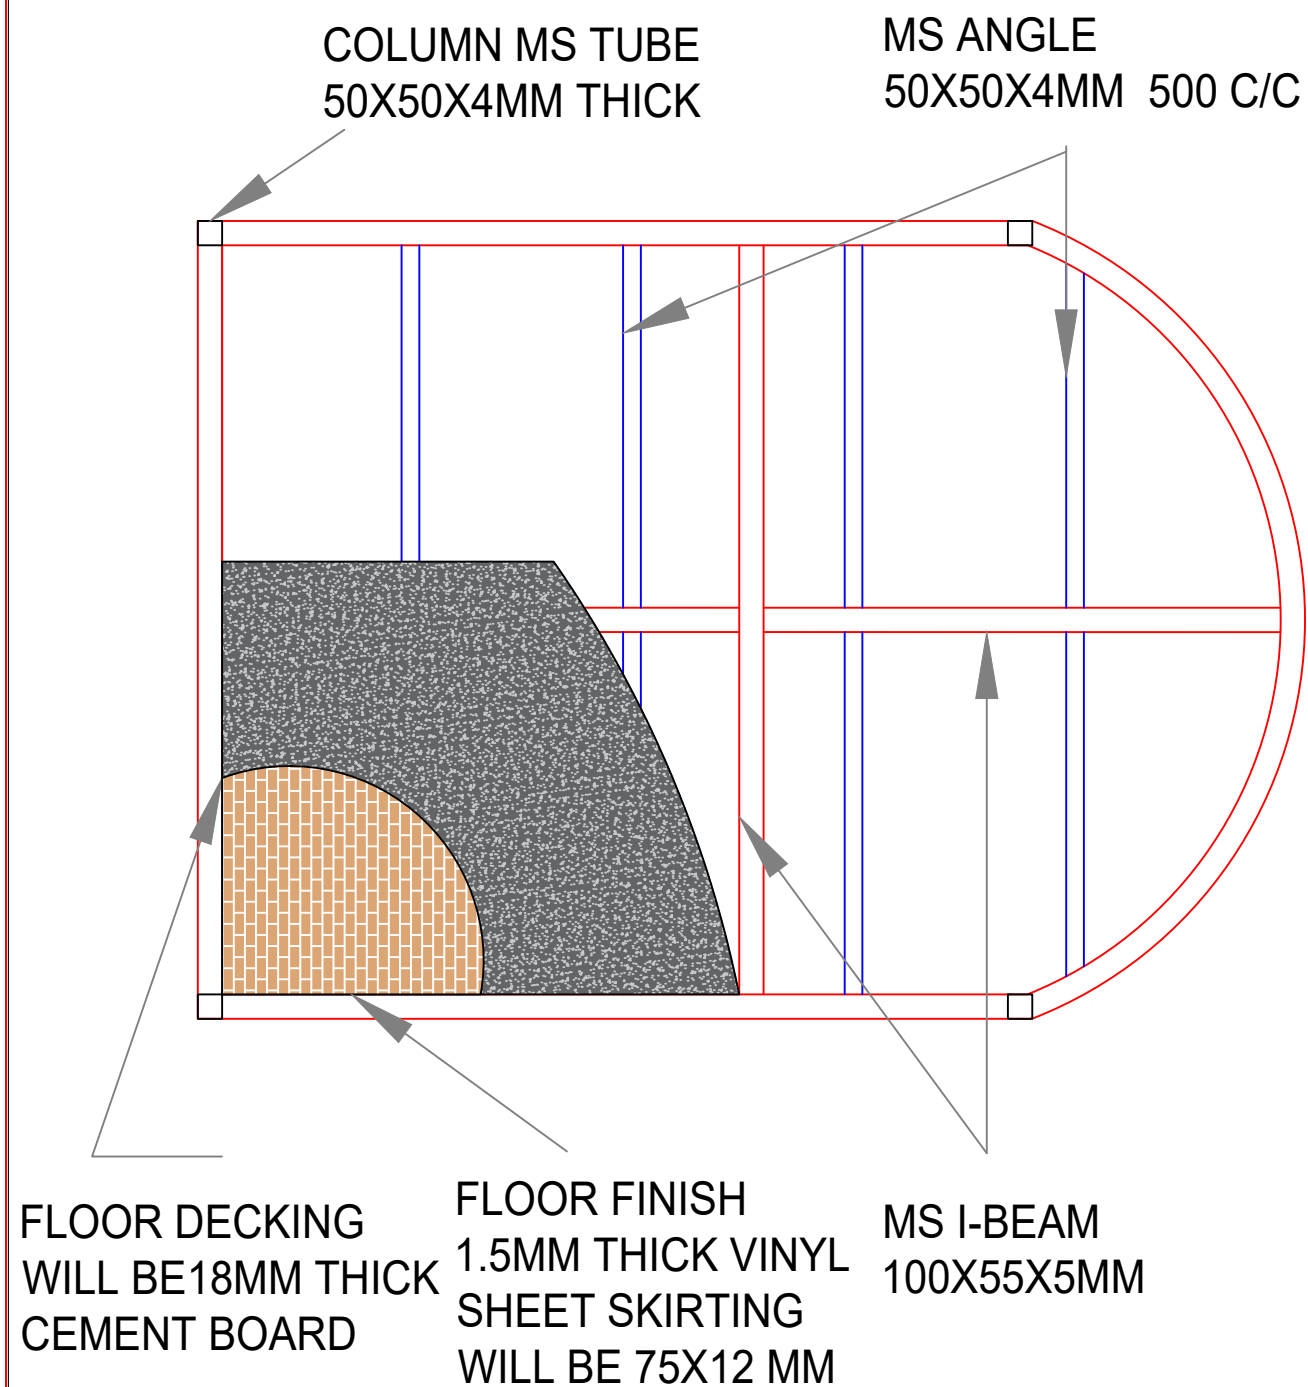

BASE FRAME

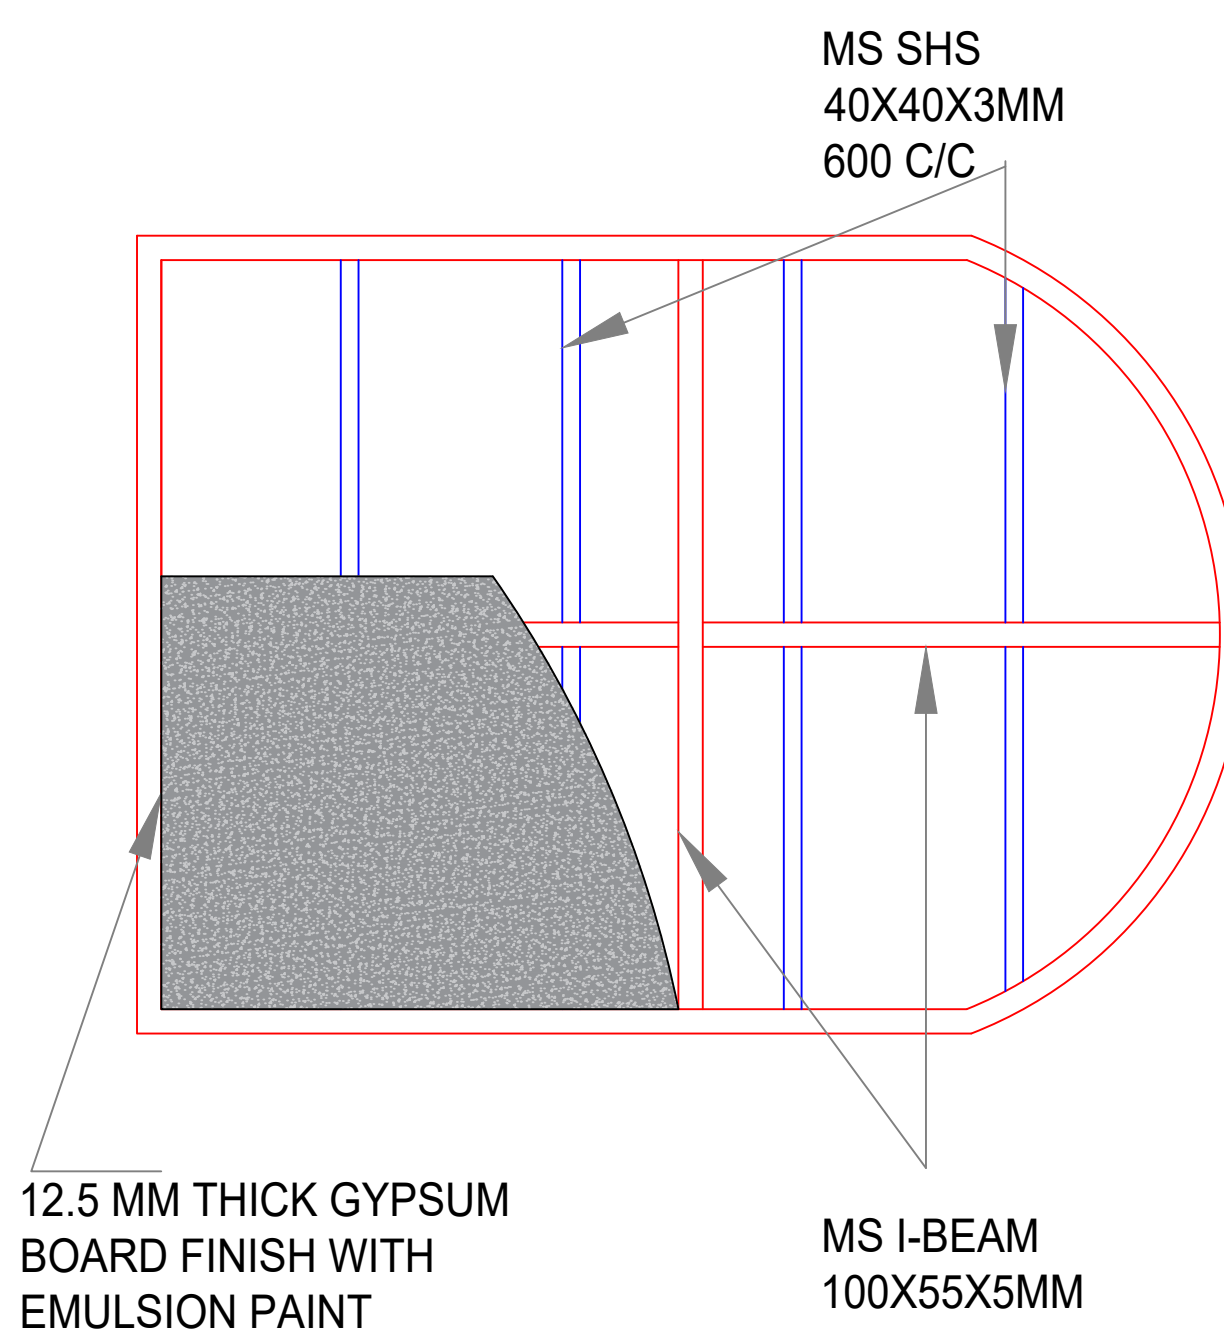

TOP FRAME

APPROVED
By Dirk Booysen at 3:00 pm, Apr 26, 2021

LEGEND

ELECTRICAL

	13A SWITCH SOCKET(Double)
	15A SWITCH SOCKET
	WATER HEATER 12 gl.
	ISOLATOR-32A (IP 65,TP/SP)
	DISTRIBUTION BOARD
	ONE GANG ONE WAY SWITCH
	DOUBLE POLE SWITCH NEON-20A
	DATA POINT (provision only)
	TEL. POINT (provision only)
	13A SWITCH SOCKET
	REF.FLUORESCENT FITTING-4x18w (60x60)
	FLUORESCENT FITTING-1x36w
	FLUORESCENT FITTING-2x36w
	BULKHEAD LAMP
	EXHAUST FAN (6")

PLUMBING

	W/C EUROPEAN		KITCHEN SINK
	W/C ASIAN		WATER HEATER
	WASH BASIN		FLOOR TRAP
	URINAL		WATER TAP
	SHOWER TRAY		

PREFAB
Space Box Prefab Houses Ind L.L.C
Tel: 06-5214409 Fax:06-5214409
Mob: 050-4738366
Email:arif@prefabuae.com
www.prefabuae.com

APPROVED BY CLIENT

**GREEN BRANCH
CONTACTING**

APPROVED BY: DESIGNER
ASIF LATIF

APPROVED BY: PRODUCTION MANAGER
MR. SALIM

DWG. NO. - FLOOR : Nos.
G.F ONLY


DRAWING TITLE : **SECURITY CABIN**

SHEET CONTENTS **BASE & TOP FRAME** AREA

DATE: **14-04-2021** PROJECT PHASE :

REV.	DESCRIPTION	DATE

Location	SCALE : NTS	SHEET NO: 01
DRAWN BY AL	PAPER SIZE : A3	

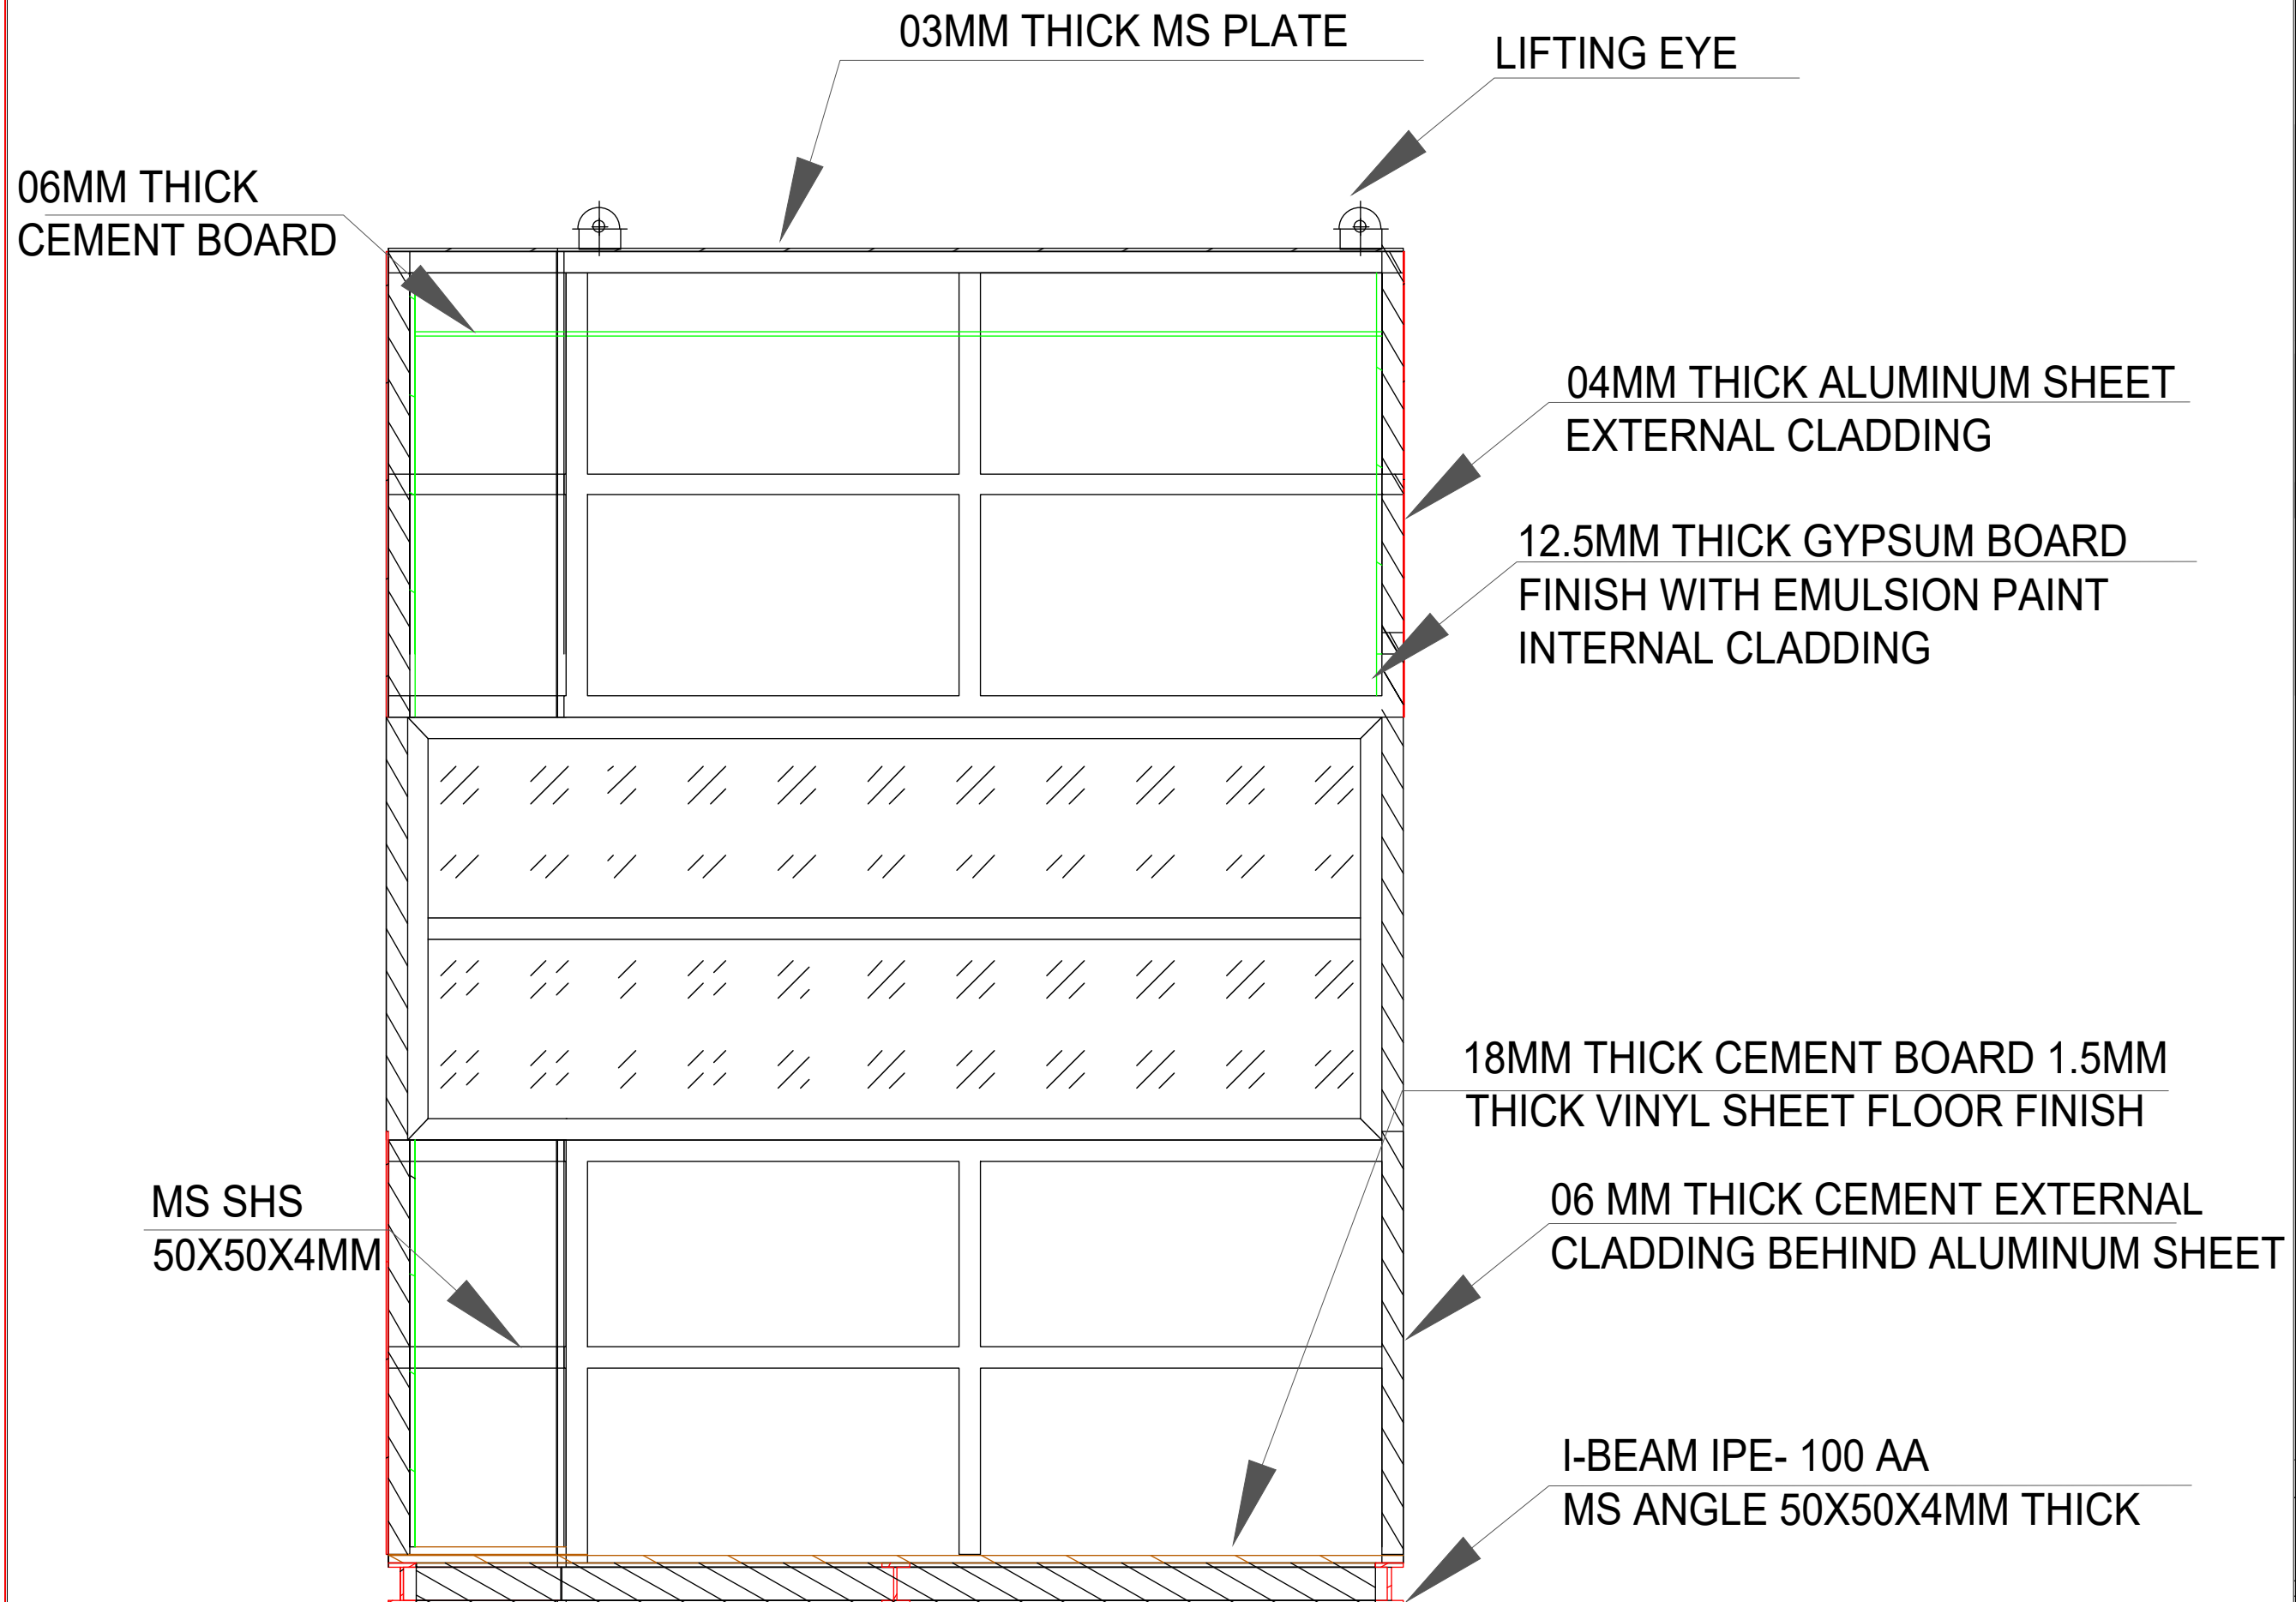

APPROVED
By Dirk Booysen at 3:00 pm, Apr 26, 2021

LEGEND

ELECTRICAL

	13A SWITCH SOCKET(Double)
	15A SWITCH SOCKET
	WATER HEATER 12 gl.
	ISOLATOR-32A (1P 65,TP/SP)
	DISTRIBUTION BOARD
	ONE GANG ONE WAY SWITCH
	DOUBLE POLE SWITCH NEON-20A
	DATA POINT (provision only)
	TEL. POINT (provision only)
	13A SWITCH SOCKET
	REF.FLUORESCENT FITTING-4x18w (60x60)
	FLUORESCENT FITTING-1x36w
	FLUORESCENT FITTING-2x36w
	BULKHEAD LAMP
	EXHAUST FAN (6")

PLUMBING

	W/C EUROPEAN		KITCHEN SINK
	W/C ASIAN		WATER HEATER
	WASH BASIN		FLOOR TRAP
	URINAL		WATER TAP
	SHOWER TRAY		

PREFAB
Space Box Prefab Houses Ind L.L.C
Tel: 06-5214409 Fax: 06-5214409
Mob: 050-4738366
Email: arif@prefabuae.com
www.prefabuae.com

APPROVED BY: CLIENT

**GREEN BRANCH
CONTACTING**

APPROVED BY: DESIGNER
ASIF LATIF

APPROVED BY: PRODUCTION MANAGER
MR. SALIM

DWG. NO. - FLOOR . Nos.
G.F ONLY

DRAWING TITLE : **SECURITY CABIN**

SHEET CONTENTS FLOOR & ELEVATION DETAIL AREA

DATE: **14-04-2021** PROJECT PHASE :

REV:	DESCRIPTION	DATE
Location	SCALE : NTS	SHEET NO:
DRAWN BY: AL	PAPER SIZE : A3	01

