
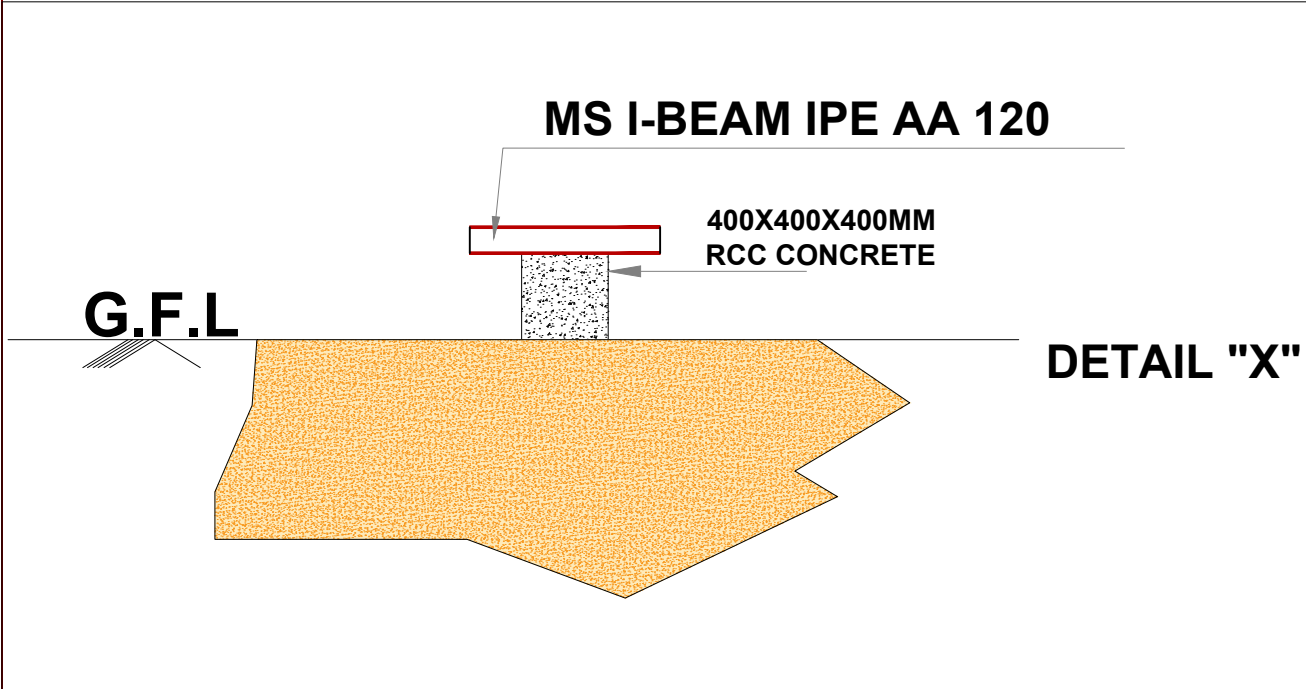


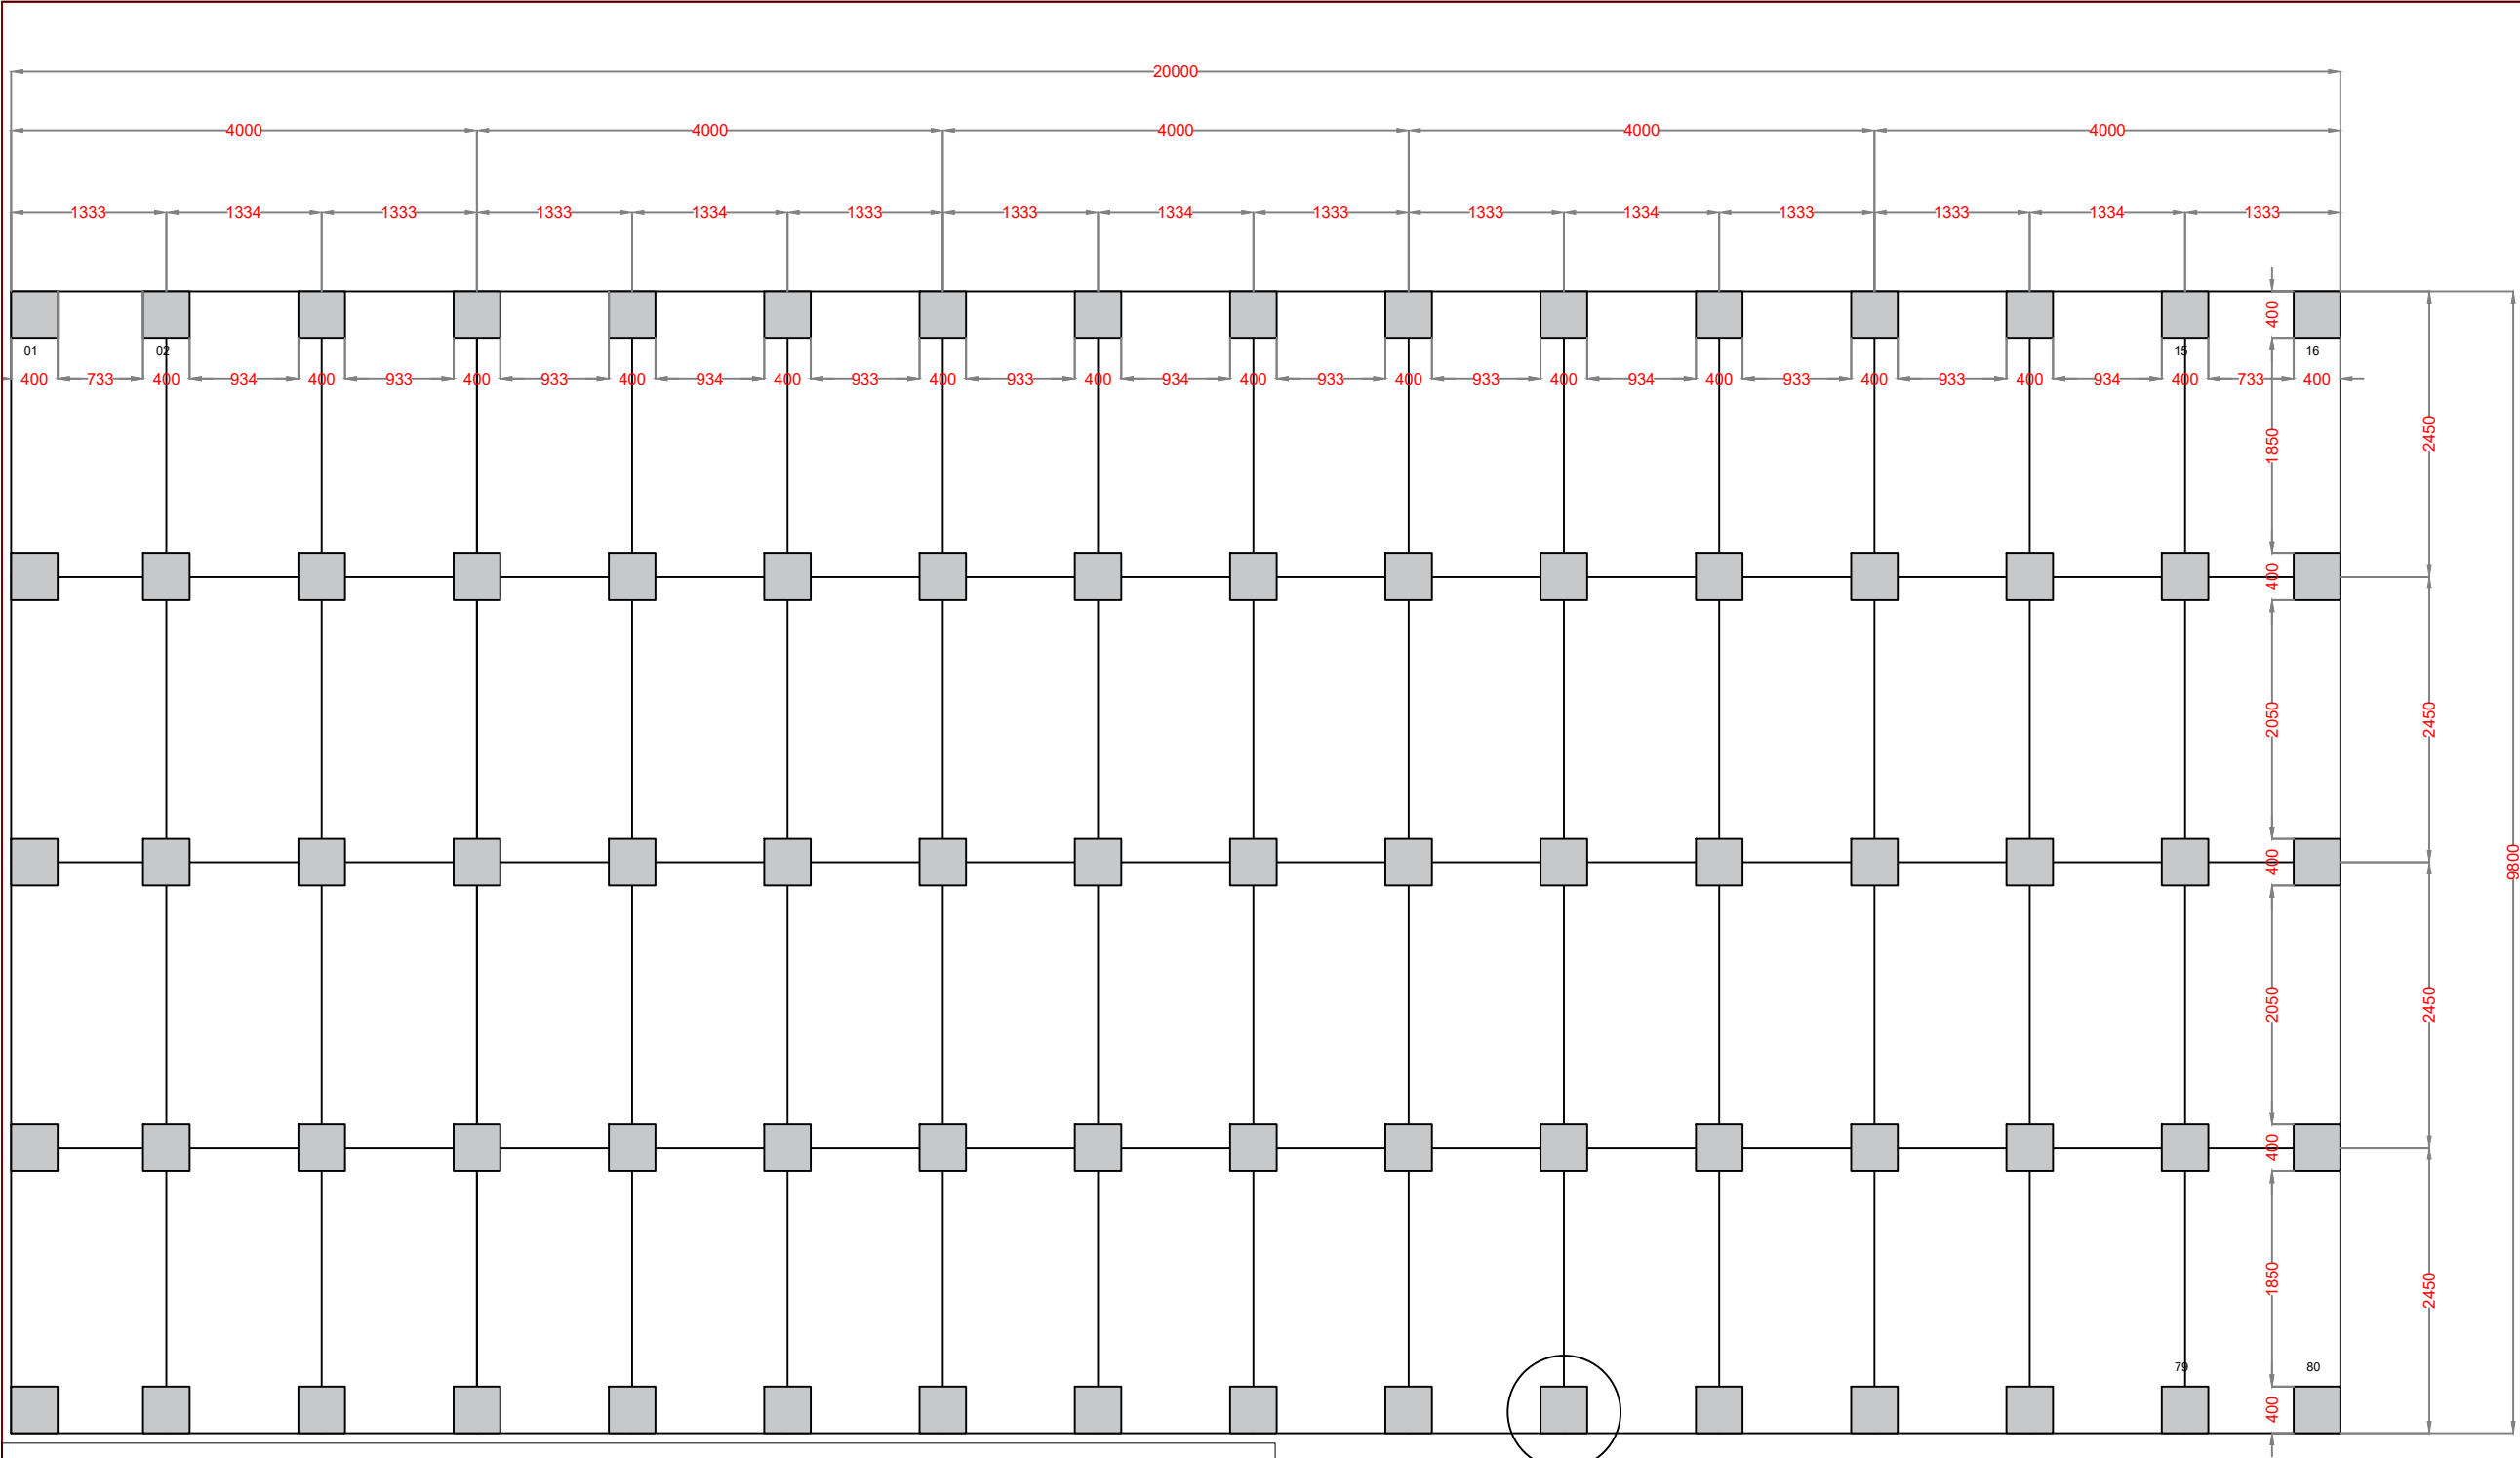

LEGEND

ELECTRICAL

	13A SWITCH SOCKET(Double)
	15A SWITCH SOCKET
	WATER HEATER 12 gl.
	ISOLATOR-32A (IP 65,TP/SP)
	DISTRIBUTION BOARD
	ONE GANG ONE WAY SWITCH
	DOUBLE POLE SWITCH NEON-20A
	DATA POINT (provision only)
	TEL. POINT (provision only)
	13A SWITCH SOCKET
	REF.FLUORESCENT FITTING-4x18w (60x60)
	FLUORESCENT FITTING-1x36w
	FLUORESCENT FITTING-2x36w
	BULKHEAD LAMP
	EXHAUST FAN (6")

PLUMBING

	W/C EUROPEAN		KITCHEN SINK
	W/C ASIAN		WATER HEATER
	WASH BASIN		FLOOR TRAP
	URINAL		WATER TAP
	SHOWER TRAY		

PREFAB

Space Box Prefab Houses Ind L.L.C
Tel: 06-5214409 Fax:06-5214409
Mob: 050-4738366
Email:arif@prefabuae.com
www.prefabuae.com

APPROVED BY CLIENT

DE TECH
CONTRACTING

APPROVED BY: DESIGNER

ASIF LATIF

APPROVED BY:PRODUCTION MANAGER

MR. SALIM

DWG. NO.	-	FLOOR : Nos.	G.F ONLY
----------	---	--------------	----------

DRAWING TITLE :

PREFAB SITE OFFICE

SHEET CONTENTS	FOUNDATION	AREA	198 SQM
----------------	------------	------	---------

DATE:	08-08-2022	CONSULTANT:	
-------	------------	-------------	--

REV:	DESCRIPTION	DATE	

Location	SCALE :	SHEET NO:
DRAWN BY	AL	NTS
	PAPER SIZE :	A4
		01

LEGEND

ELECTRICAL

	13A SWITCH SOCKET (Double)
	15A SWITCH SOCKET
	WATER HEATER 12 gl.
	ISOLATOR-32A (IP 65,TP/SP)
	DISTRIBUTION BOARD
	ONE GANG ONE WAY SWITCH
	DOUBLE POLE SWITCH NEON-20A
	DATA POINT (provision only)
	TEL. POINT (provision only)
	13A SWITCH SOCKET
	REF-FLUORESCENT FITTING-4x18w (60x60)
	FLUORESCENT FITTING-1x36w
	FLUORESCENT FITTING-2x36w
	BULKHEAD LAMP
	EXHAUST FAN (6")

PLUMBING

	W/C EUROPEAN		KITCHEN SINK
	W/C ASIAN		WATER HEATER
	WASH BASIN		FLOOR TRAP
	URINAL		WATER TAP
	SHOWER TRAY		



APPROVED BY CLIENT

DE TECH
CONTRACTING

APPROVED BY: DESIGNER

ASIF LATIF

APPROVED BY: PRODUCTION MANAGER

MR. SALIM

DWG. NO.

FLOOR . Nos.

G.F ONLY

DRAWING TITLE :

TITLE: **PREFAB SITE OFFICE**

SHEET CONTENTS ELEVATION DETAIL


AREA 198 SOM

DATE:


08-08-2022

--	--


REV:	DESCRIPTION	DATE
Location	SCALE : NTS	SHEET NO: 01
DRAWN BY AL	PAPER SIZE : A4	

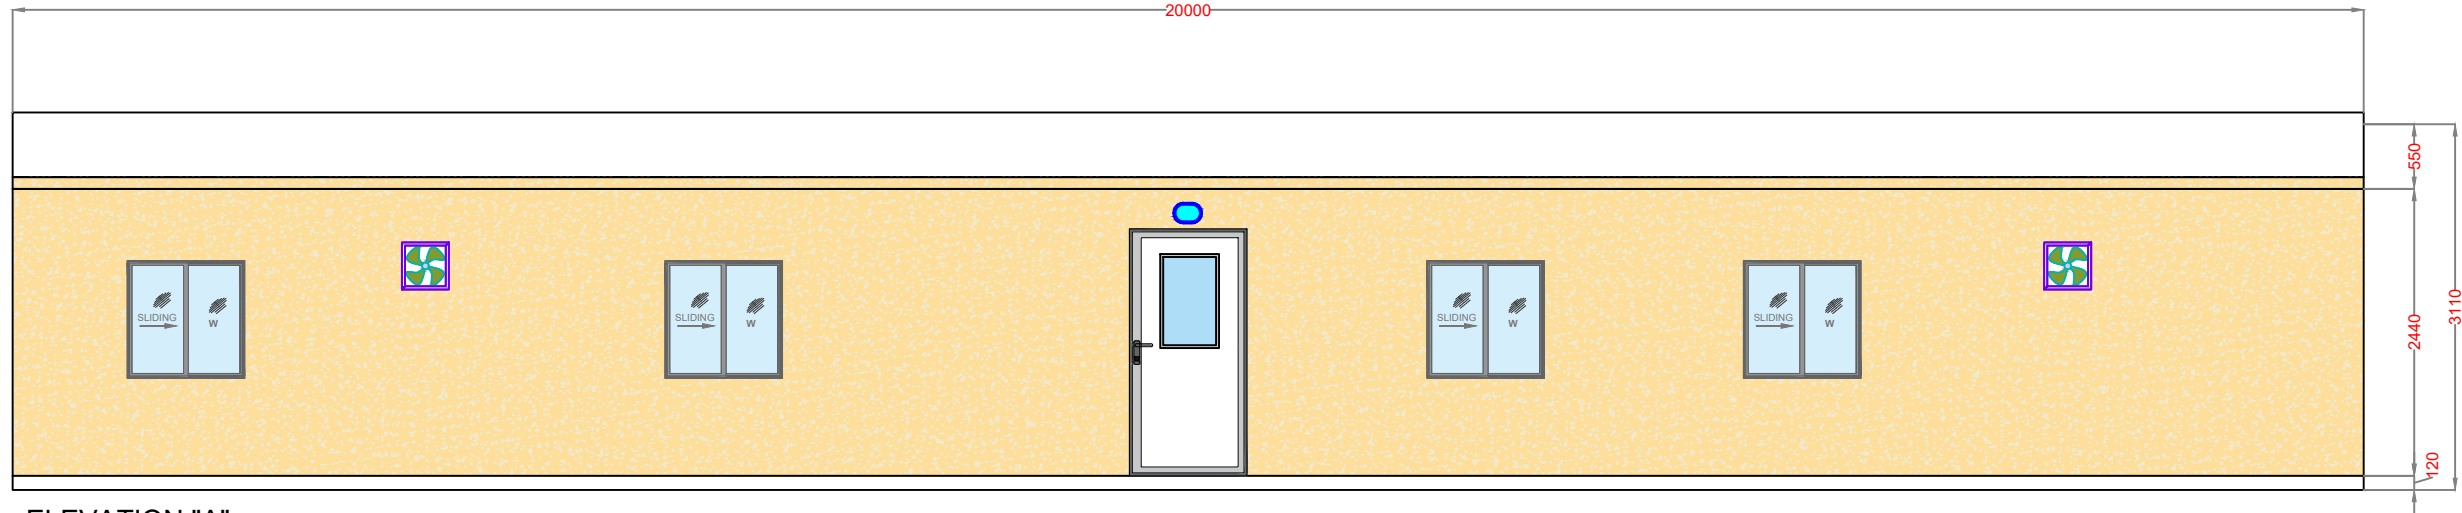


ELEVATION "A"

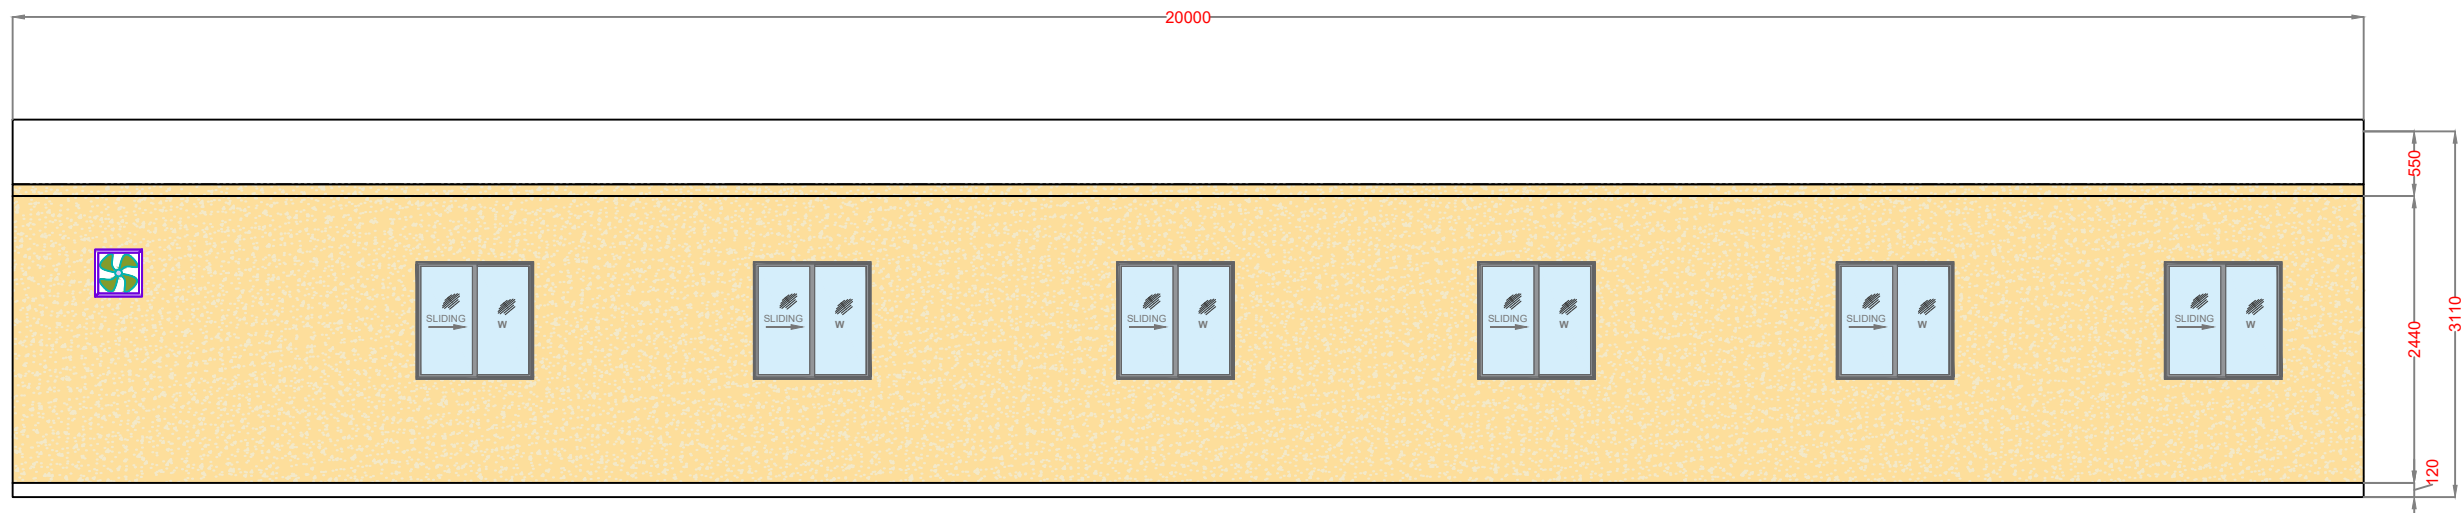

ELEVATION "C"

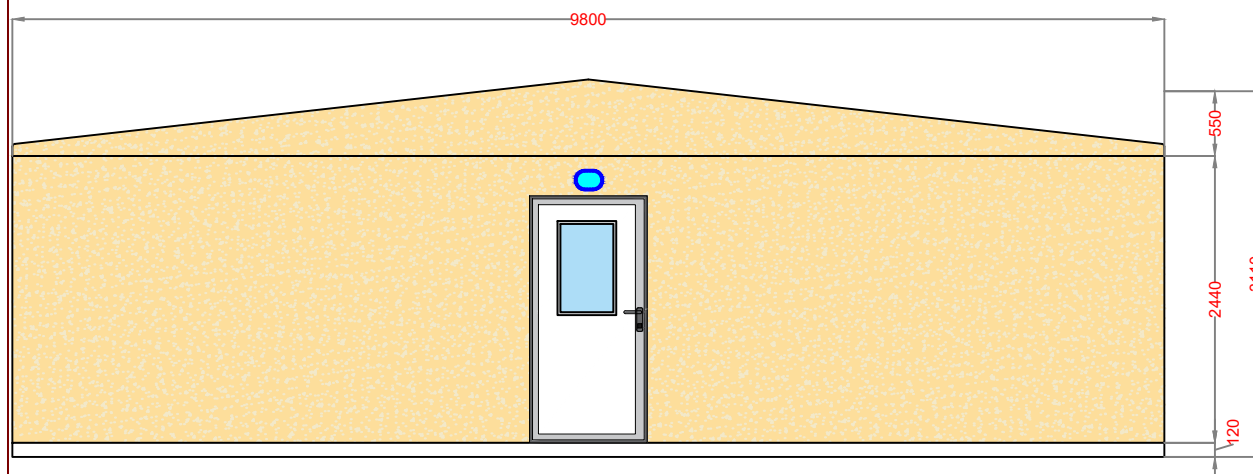

ELEVATION "B"

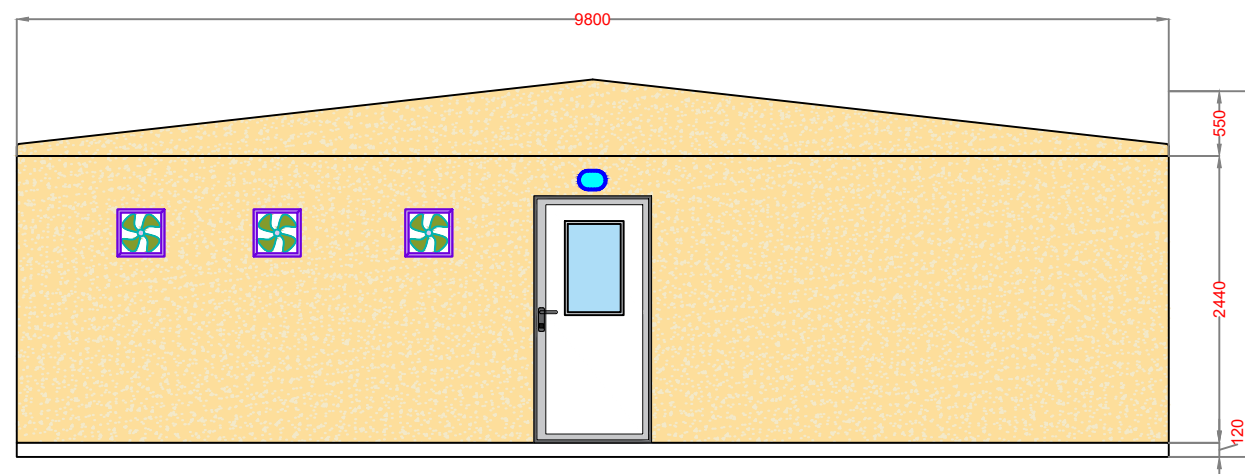

ELEVATION "D"

LEGEND

ELECTRICAL

	13A SWITCH SOCKET(Double)
	15A SWITCH SOCKET
	WATER HEATER 12 gl.
	ISOLATOR-32A (IP 65,TP/SP)
	DISTRIBUTION BOARD
	ONE GANG ONE WAY SWITCH
	DOUBLE POLE SWITCH NEON-20A
	DATA POINT (provision only)
	TEL. POINT (provision only)
	13A SWITCH SOCKET
	REF.FLUORESCENT FITTING-4x18w (60x60)
	FLUORESCENT FITTING-1x36w
	FLUORESCENT FITTING-2x36w
	BULKHEAD LAMP
	EXHAUST FAN (6")

PLUMBING

	W/C EUROPEAN		KITCHEN SINK
	W/C ASIAN		WATER HEATER
	WASH BASIN		FLOOR TRAP
	URINAL		WATER TAP
	SHOWER TRAY		



PREFAB

Space Box Prefab Houses Ind L.L.C
Tel: 06-5214409 Fax:06-5214409
Mob: 050-4738366
Email:arif@prefabuae.com
www.prefabuae.com

APPROVED BY CLIENT

DE TECH
CONTRACTING

APPROVED BY: DESIGNER

ASIF LATIF

APPROVED BY:PRODUCTION MANAGER

MR. SALIM

DWG. NO.

-

FLOOR - Nos.

G.F ONLY

DRAWING TITLE :

PREFAB SITE OFFICE

SHEET CONTENTS

SECTION

AREA 198 SQM

DATE:

08-08-2022

CONSULTANT:

REV:	DESCRIPTION	DATE
Location	SCALE : NTS	SHEET NO:
DRAWN BY	PAPER SIZE : A4	01

LEGEND

ELECTRICAL

	13A SWITCH SOCKET(Double)
	15A SWITCH SOCKET
	WATER HEATER 12 gl.
	ISOLATOR-32A (IP 65,TP/SP)
	DISTRIBUTION BOARD
	ONE GANG ONE WAY SWITCH
	DOUBLE POLE SWITCH NEON-20A
	DATA POINT (provision only)
	TEL. POINT (provision only)
	13A SWITCH SOCKET
	REF.FLUORESCENT FITTING-4x18w (60x60)
	FLUORESCENT FITTING-1x36w
	FLUORESCENT FITTING-2x36w
	BULKHEAD LAMP
	EXHAUST FAN (6")

PLUMBING

	W/C EUROPEAN		KITCHEN SINK
	W/C ASIAN		WATER HEATER
	WASH BASIN		FLOOR TRAP
	URINAL		WATER TAP
	SHOWER TRAY		

 **PREFAB**

Space Box Prefab Houses Ind L.L.C
Tel: 06-5214409 Fax:06-5214409
Mob: 050-4738366
Email:arif@prefabuae.com
www.prefabuae.com

APPROVED BY CLIENT

DE TECH
CONTRACTING

APPROVED BY: DESIGNER

ASIF LATIF

APPROVED BY:PRODUCTION MANAGER

MR. SALIM

DWG. NO.

FLOOR . Nos.

G.F ONLY

DRAWING TITLE :

PREFAB SITE OFFICE

SHEET CONTENTS

LIGHTING

AREA


198 SQM

DATE:

08-08-2022

CONSULTANT:

REV:	DESCRIPTION	DATE
Location	SCALE : NTS	SHEET NO:
DRAWN BY AL	PAPER SIZE : A4	01

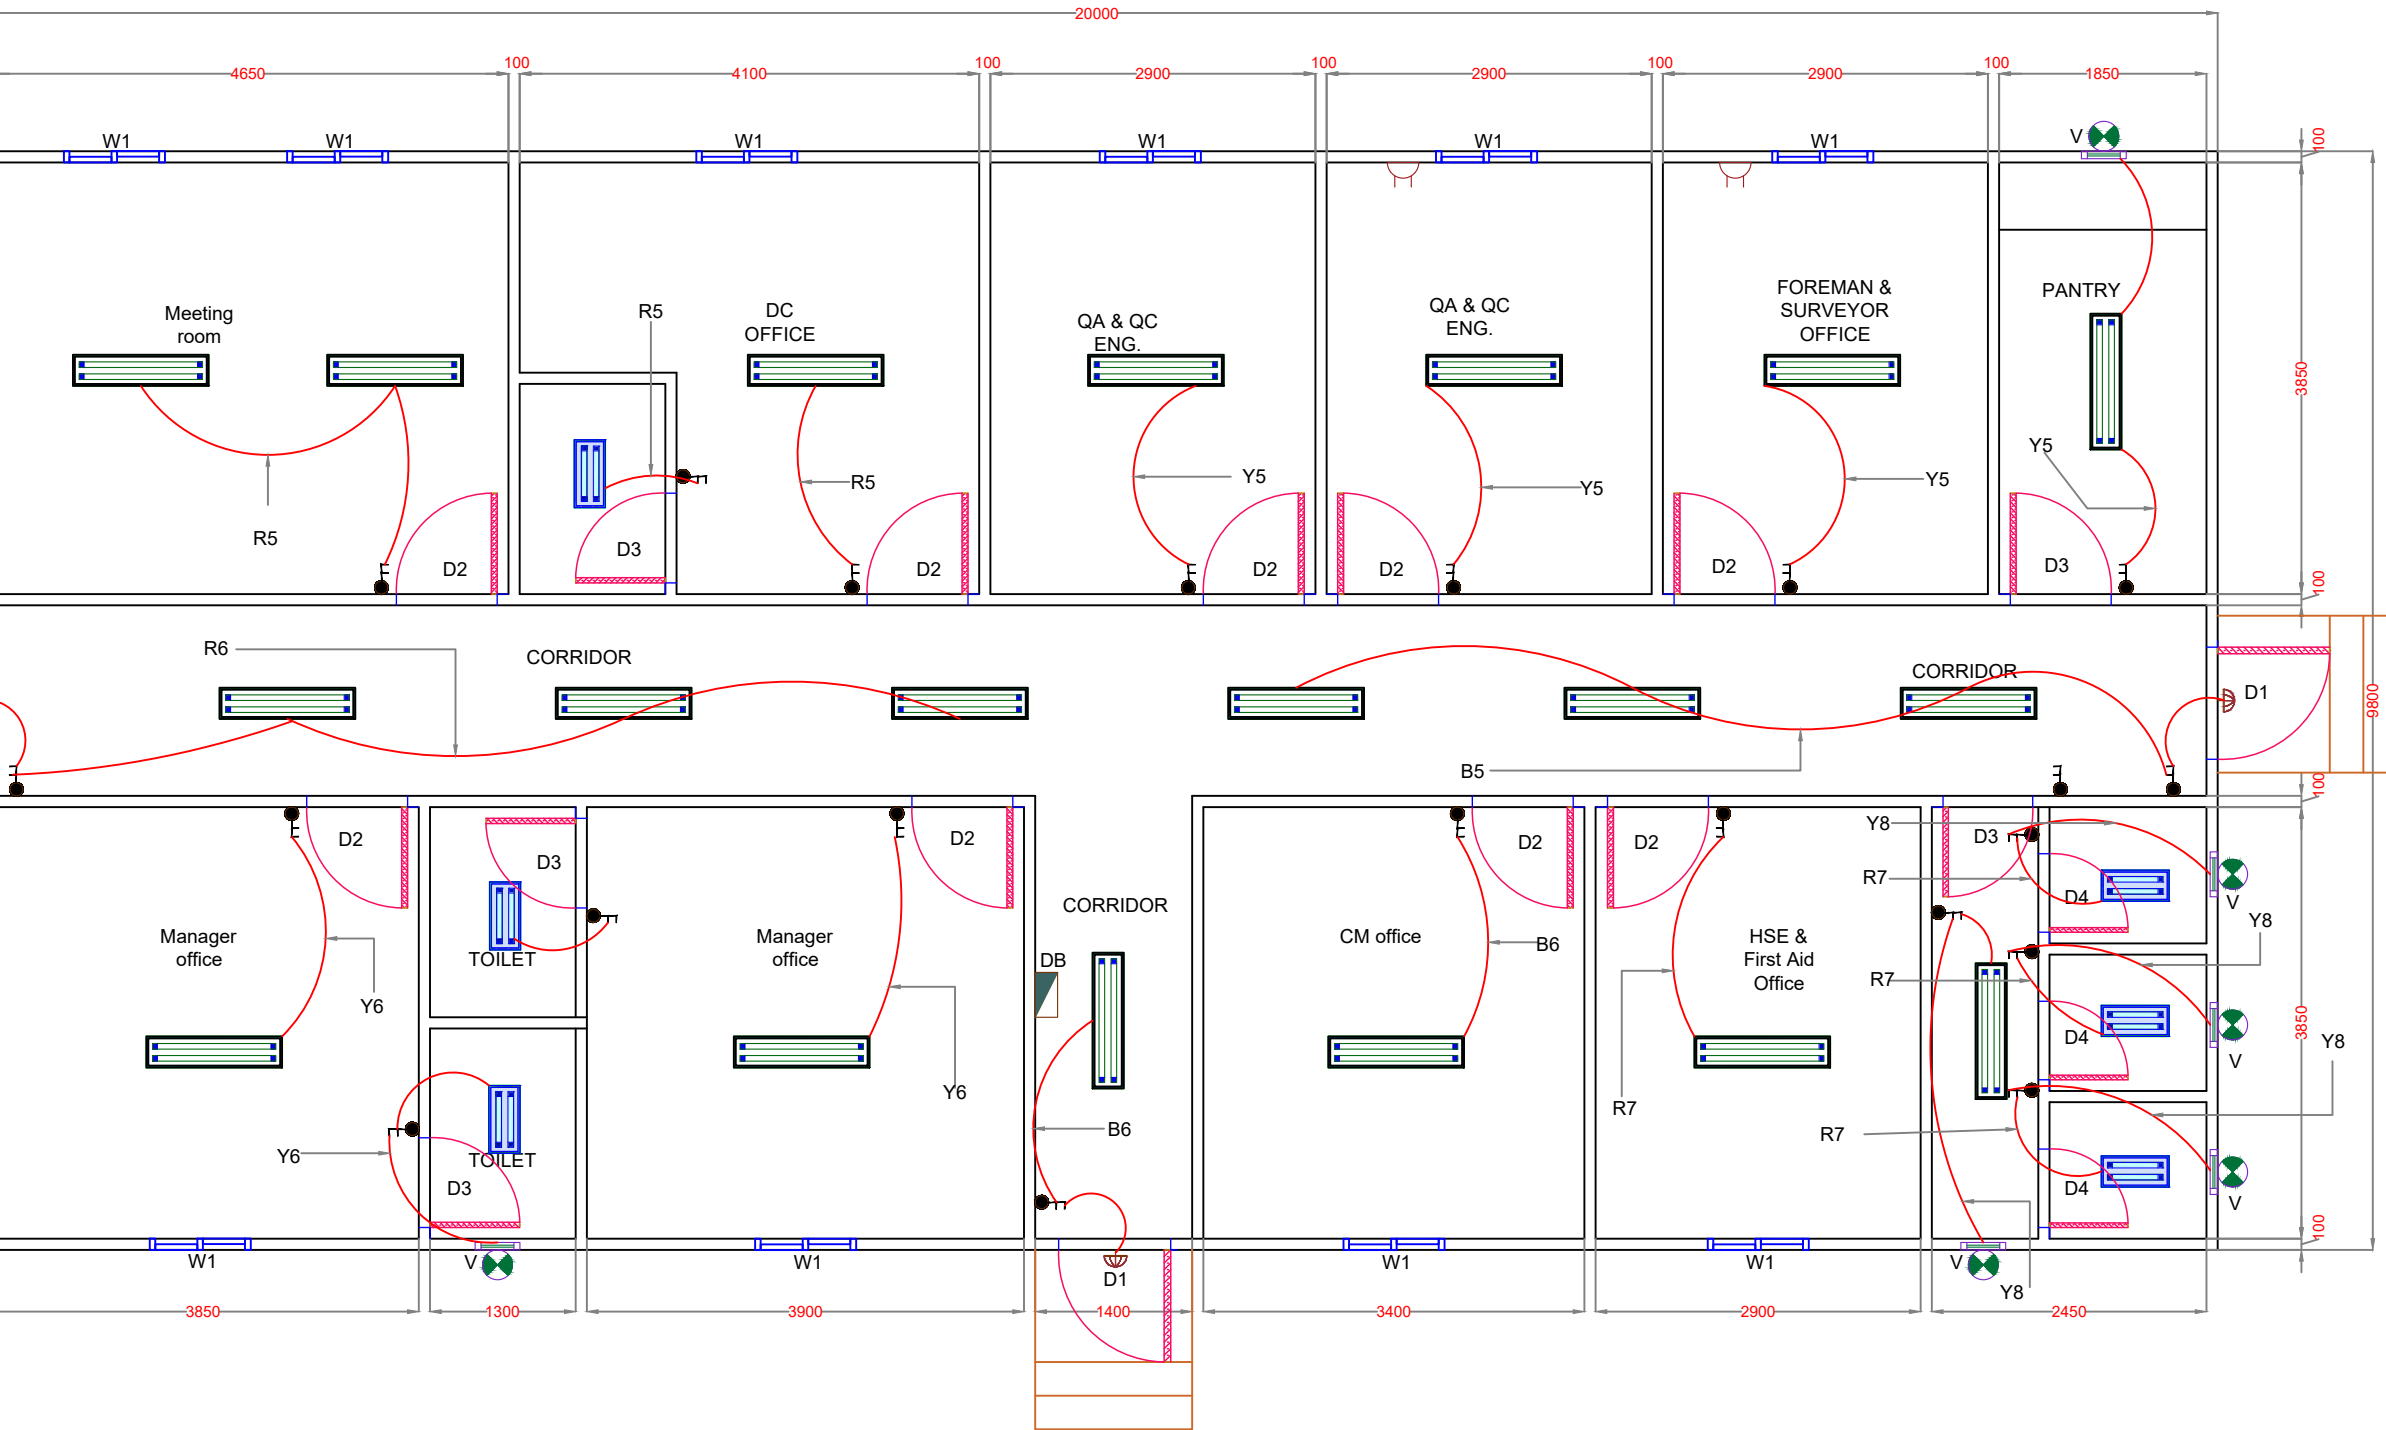

LEGEND

ELECTRICAL

	13A SWITCH SOCKET(Double)
	15A SWITCH SOCKET
	WATER HEATER 12 gl.
	ISOLATOR-32A (IP 65,TP/SP)
	DISTRIBUTION BOARD
	ONE GANG ONE WAY SWITCH
	DOUBLE POLE SWITCH NEON-20A
	DATA POINT (provision only)
	TEL. POINT (provision only)
	13A SWITCH SOCKET
	REF.FLUORESCENT FITTING-4x18w (60x60)
	FLUORESCENT FITTING-1x36w
	FLUORESCENT FITTING-2x36w
	BULKHEAD LAMP
	EXHAUST FAN (6")

PLUMBING

	W/C EUROPEAN		KITCHEN SINK
	W/C ASIAN		WATER HEATER
	WASH BASIN		FLOOR TRAP
	URINAL		WATER TAP
	SHOWER TRAY		



APPROVED BY CLIENT

DE TECH
CONTRACTING

APPROVED BY: DESIGNER

ASIF LATIF

APPROVED BY:PRODUCTION MANAGER

MR. SALIM

DWG. NO.

FLOOR . Nos.

G.F ONLY

DRAWING TITLE :

TITLE: PREFAB SITE OFFICE

SHEET CONTENTS

POWER LAYOUT

AREA 198 S

198 SQM


DATE:

08-08-2022

CONSULTANT:

CONSULTANT:

REV:	DESCRIPTION		DATE	
Location		SCALE : NTS	SHEET NO:	
DRAWN BY	AL	PAPER SIZE : A4	01	

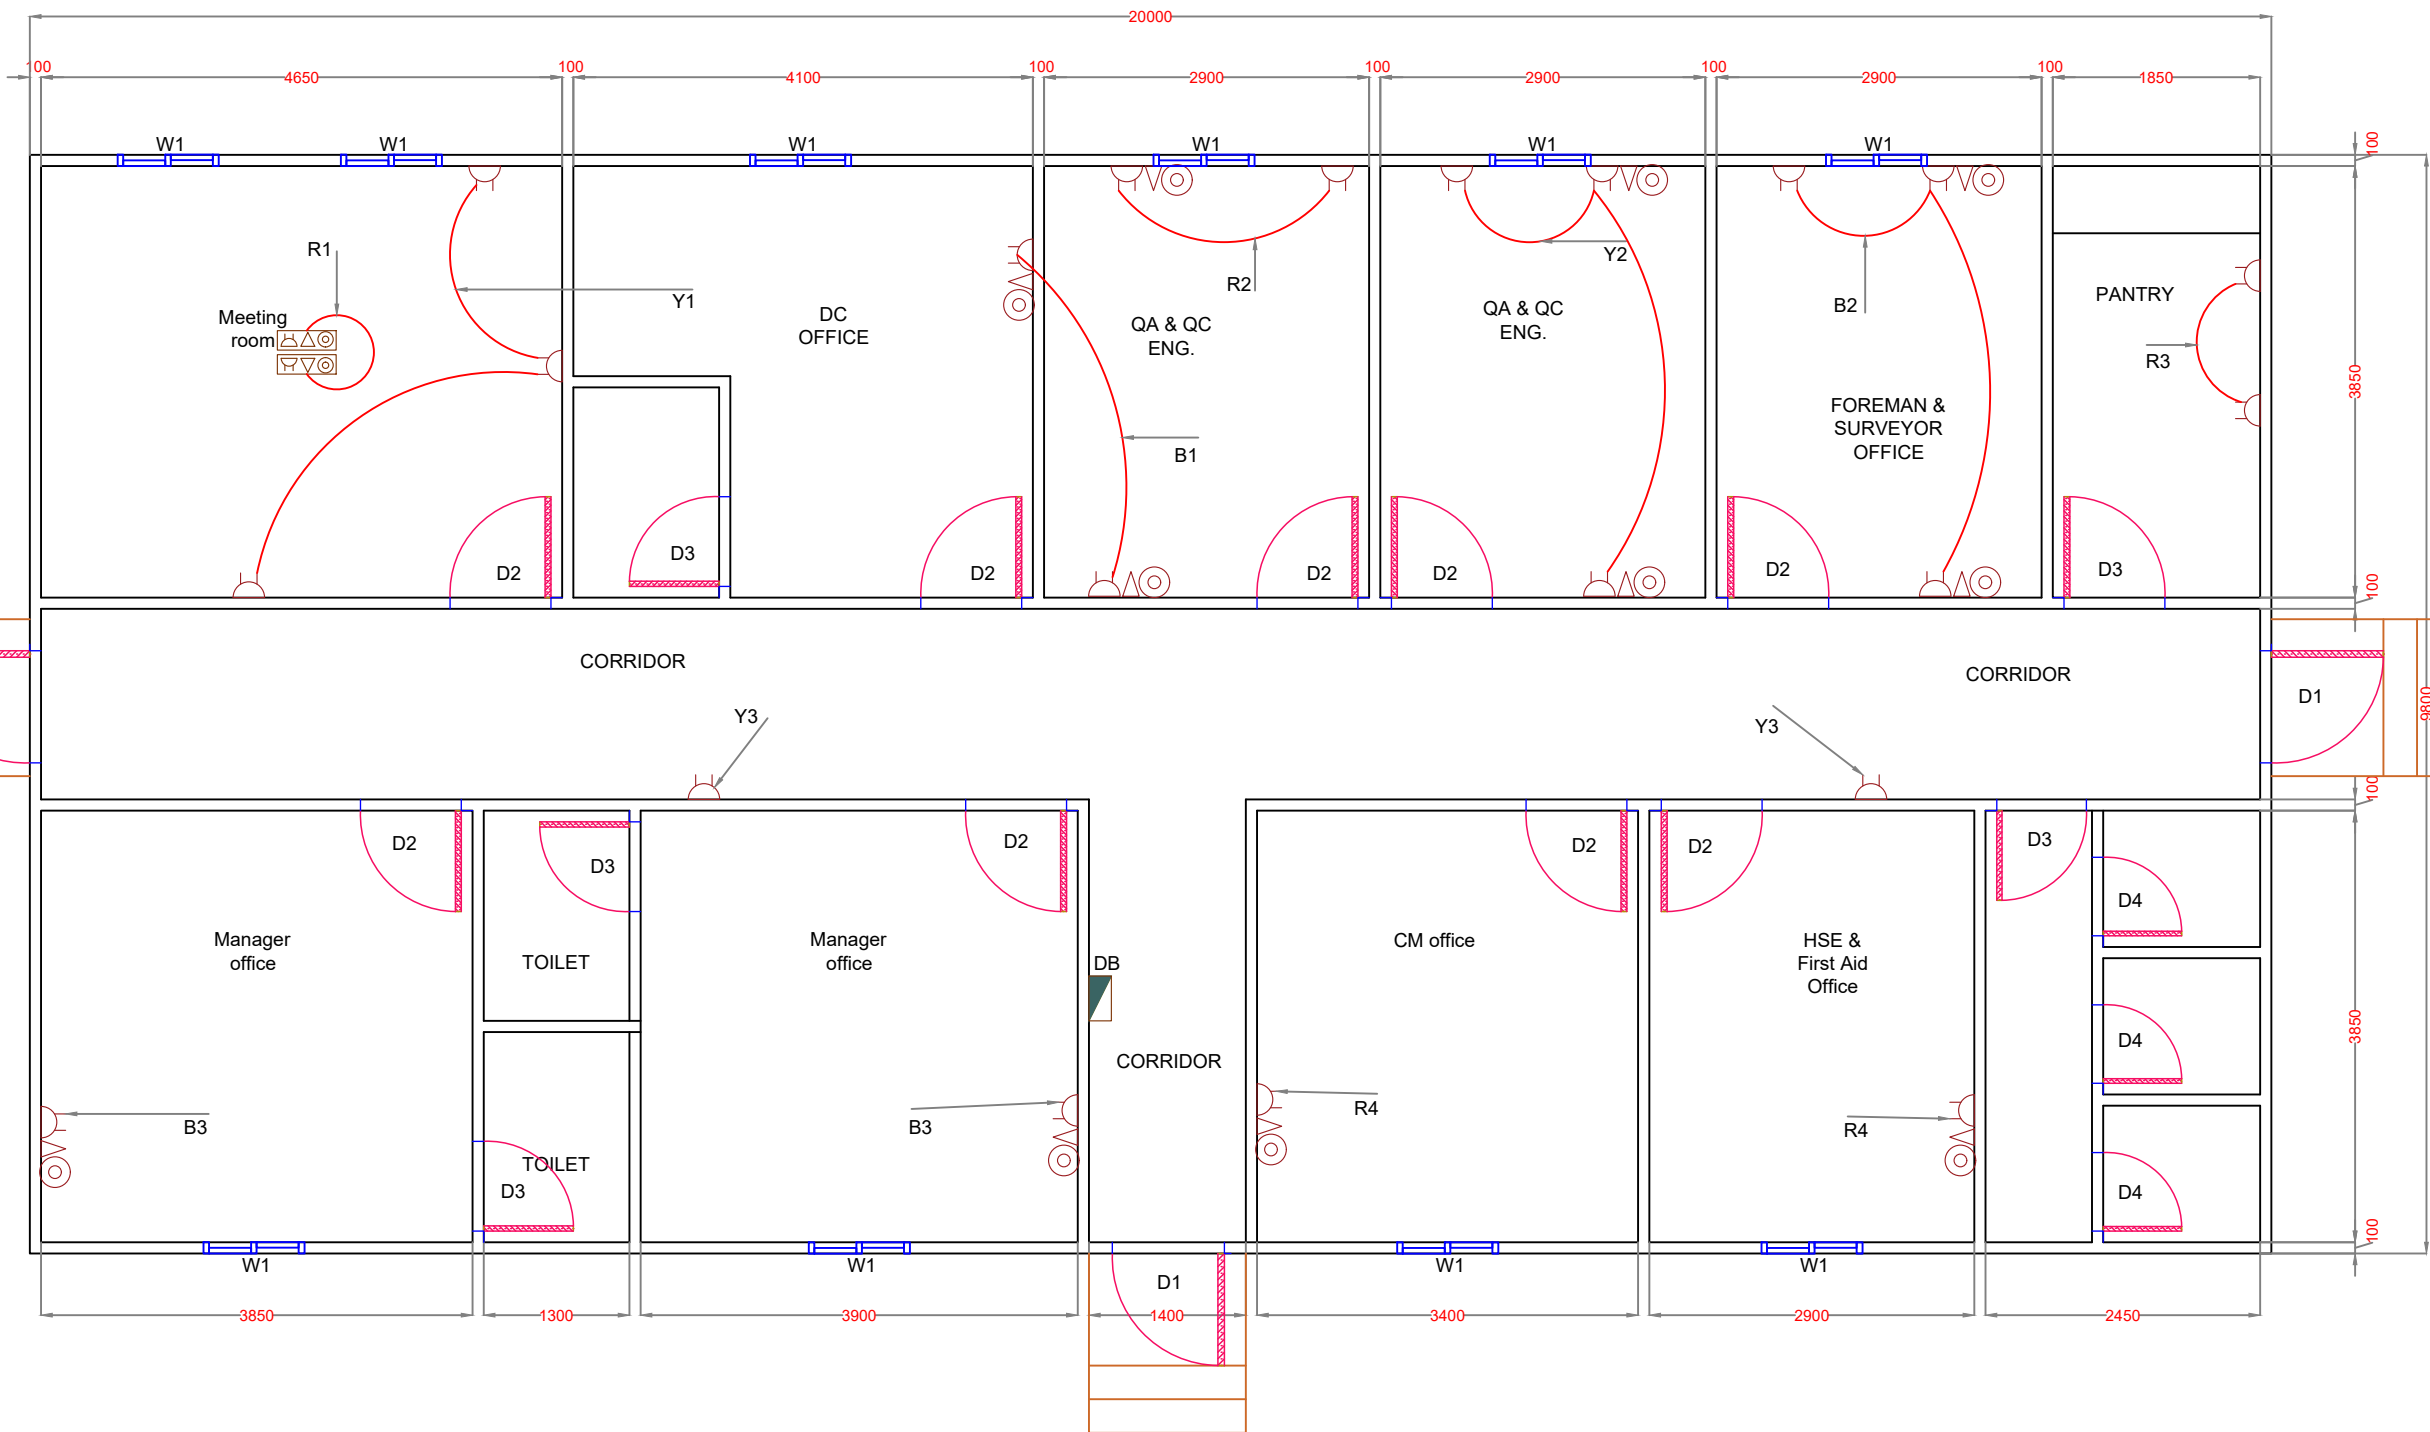

POWER LAYOUT

ELECTRICAL

PLUMBING			
	W/C EUROPEAN		KITCHEN SINK
	W/C ASIAN		WATER HEATER
	WASH BASIN		FLOOR TRAP
	URINAL		WATER TAP
	SHOWER TRAY		

APPROVED BY CLIENT

DE TECH
CONTRACTING

APPROVED BY: PRODUCTION MANAGER

MR. SALIM

DRAWING TITLE :
PREFAB SITE OFFICE

DATE: 08-08-2022	CONSULTANT:
---------------------	-------------

REV:	DESCRIPTION	DATE	
Location	SCALE : NTS	SHEET NO:	01
DRAWN BY AL	PAPER SIZE : A4		



LEGEND

ELECTRICAL

	13A SWITCH SOCKET(Double)
	15A SWITCH SOCKET
	WATER HEATER 12 gl.
	ISOLATOR-32A (IP 65, TP/SP)
	DISTRIBUTION BOARD
	ONE GANG ONE WAY SWITCH
	DOUBLE POLE SWITCH NEON-20A
	DATA POINT (provision only)
	TEL. POINT (provision only)
	13A SWITCH SOCKET
	REF.FLUORESCENT FITTING-4x18w (60x60)
	FLUORESCENT FITTING-1x36w
	FLUORESCENT FITTING-2x36w
	BULKHEAD LAMP
	EXHAUST FAN (6")

PLUMBING

	W/C EUROPEAN		KITCHEN SINK
	W/C ASIAN		WATER HEATER
	WASH BASIN		FLOOR TRAP
	URINAL		WATER TAP
	SHOWER TRAY		



PREFAB

Space Box Prefab Houses Ind L.L.C
Tel: 06-5214409 Fax:06-5214409
Mob: 050-4738366
Email:arif@prefabuae.com
www.prefabuae.com

APPROVED BY CLIENT

DE TECH
CONTRACTING

APPROVED BY: DESIGNER

ASIF LATIF

APPROVED BY:PRODUCTION MANAGER

MR. SALIM

DWG. NO.

FLOOR. Nos.

G.F ONLY

DRAWING TITLE :

PREFAB SITE OFFICE

SHEET CONTENTS

WATER SUPPLY

AREA


198 SQM

DATE:

08-08-2022

CONSULTANT:

REV:	DESCRIPTION	DATE
Location	SCALE : NTS	SHEET NO:
DRAWN BY AL	PAPER SIZE : A4	01

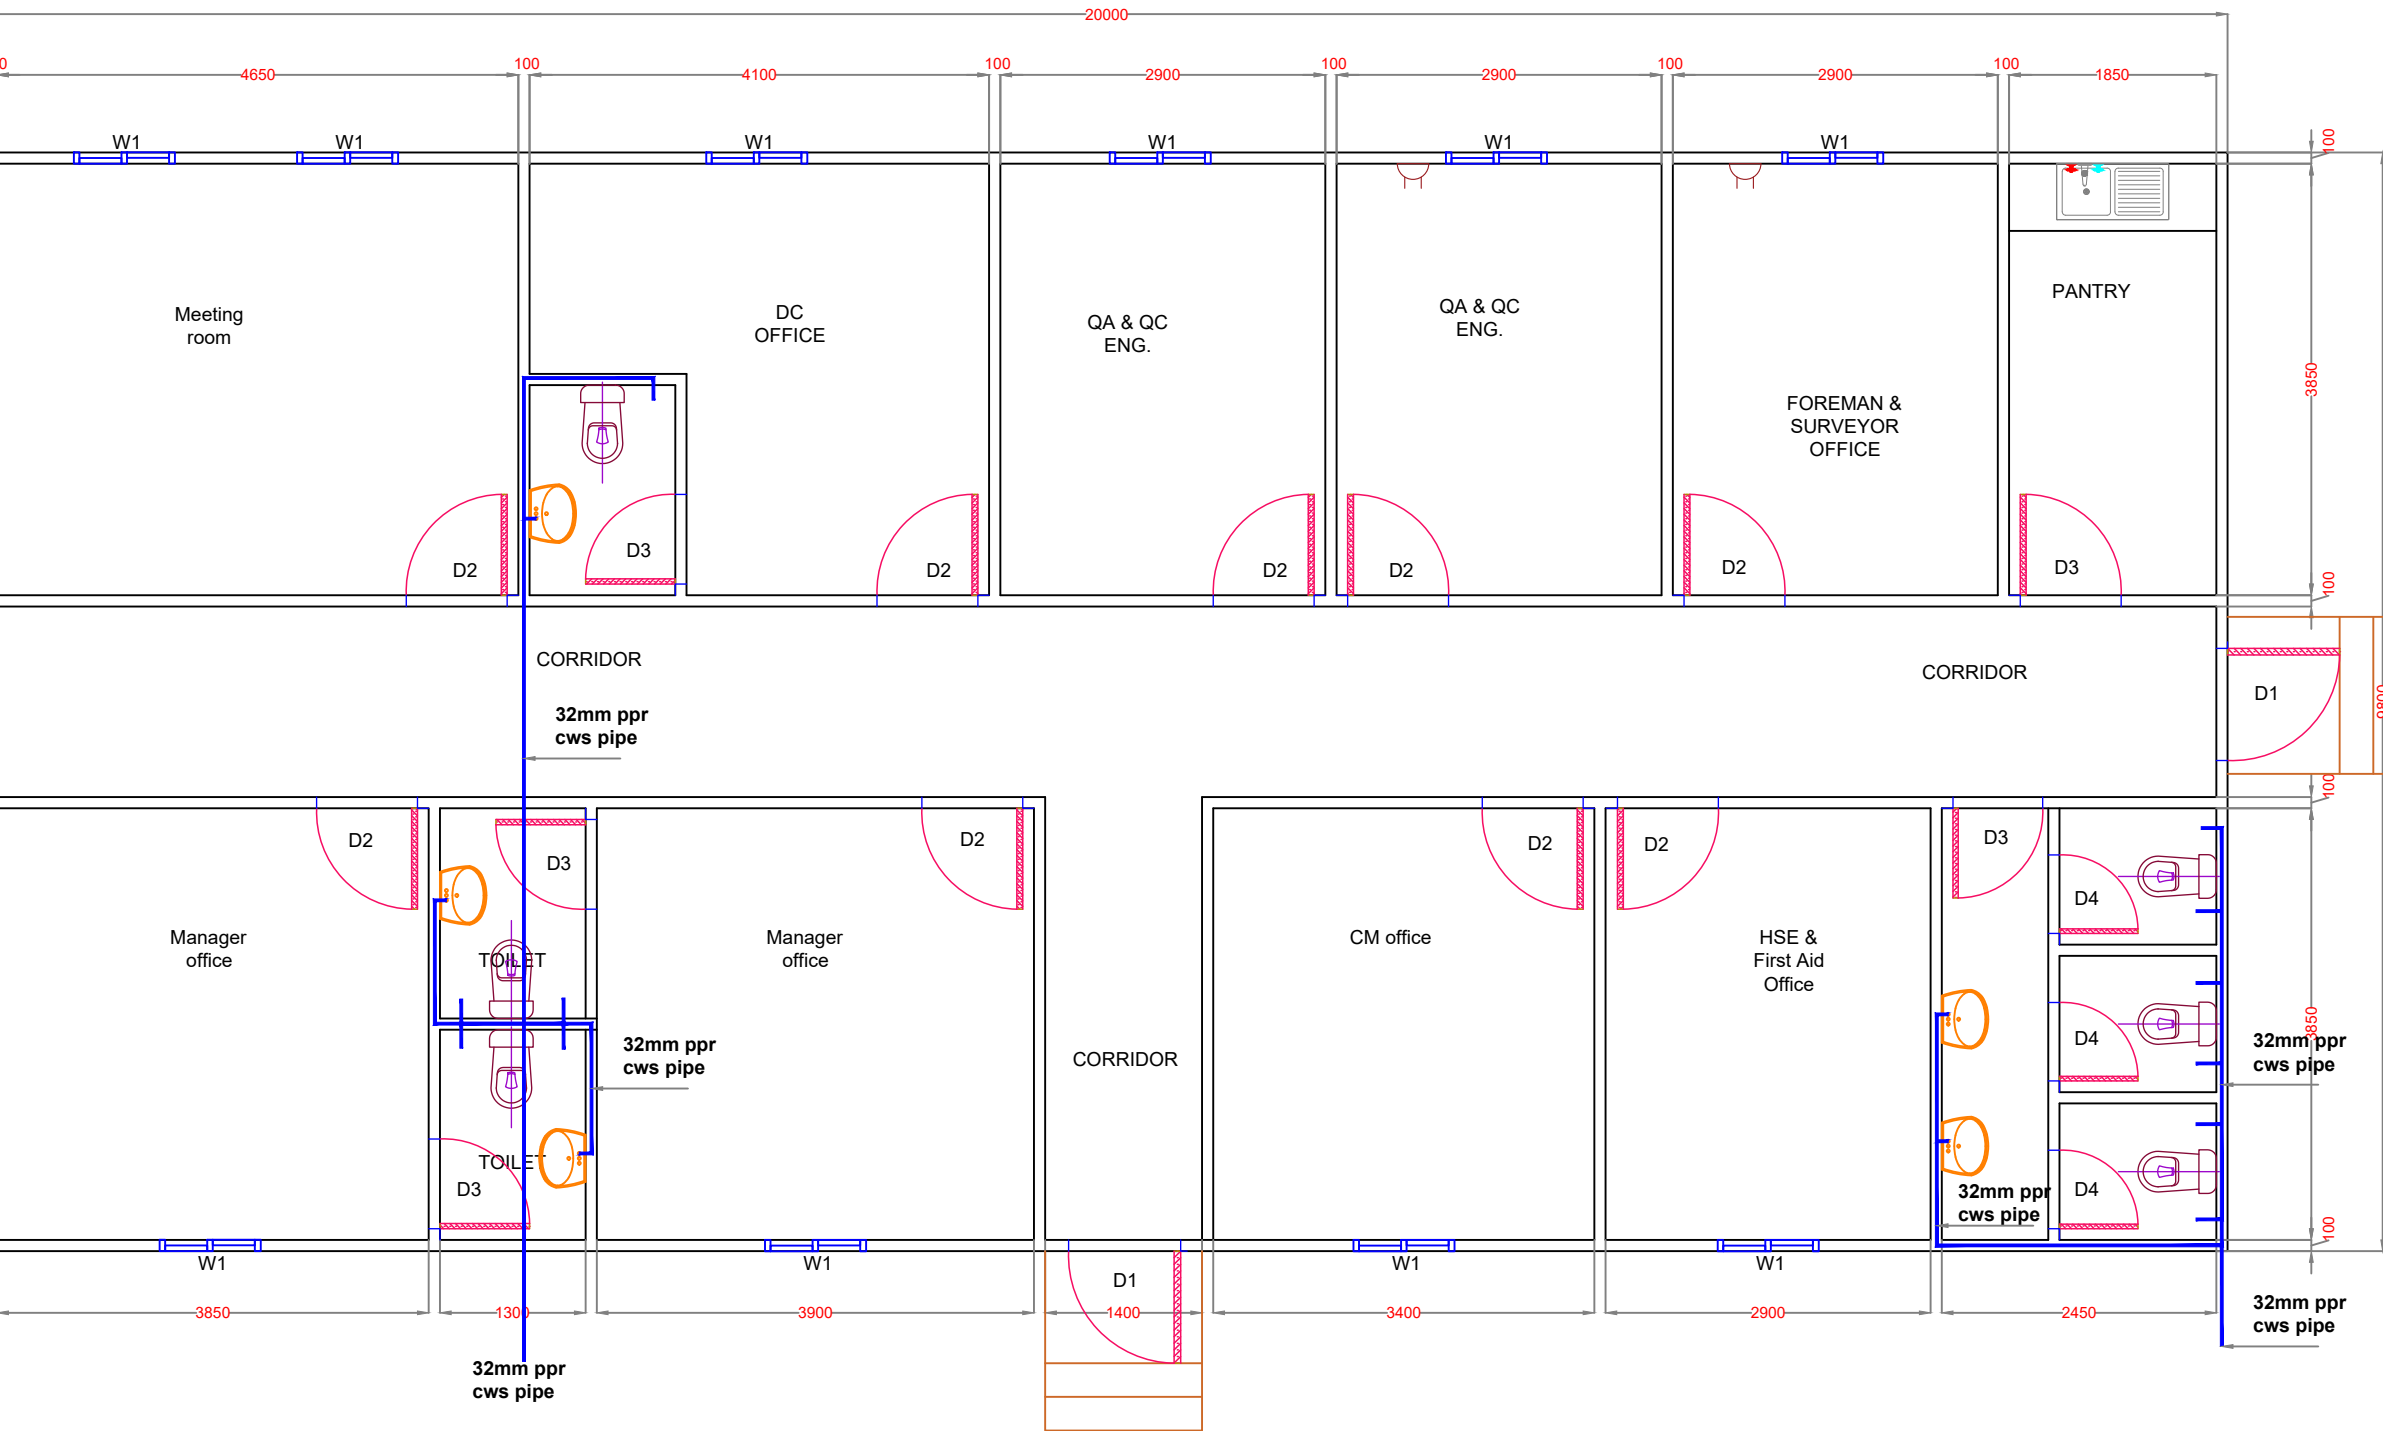

WATER SUPPLY

LEGEND

ELECTRICAL

	13A SWITCH SOCKET(Double)
	15A SWITCH SOCKET
	WATER HEATER 12 gl.
	ISOLATOR-32A (IP 65,TP/SP)
	DISTRIBUTION BOARD
	ONE GANG ONE WAY SWITCH
	DOUBLE POLE SWITCH NEON-20A
	DATA POINT (provision only)
	TEL. POINT (provision only)
	13A SWITCH SOCKET
	REF.FLUORESCENT FITTING-4x18w (60x60)
	FLUORESCENT FITTING-1x36w
	FLUORESCENT FITTING-2x36w
	BULKHEAD LAMP
	EXHAUST FAN (6")

PLUMBING

	W/C EUROPEAN		KITCHEN SINK
	W/C ASIAN		WATER HEATER
	WASH BASIN		FLOOR TRAP
	URINAL		WATER TAP
	SHOWER TRAY		



PREFAB

Space Box Prefab Houses Ind L.L.C
Tel: 06-5214409 Fax:06-5214409
Mob: 050-4738366
Email:arif@prefabuae.com
www.prefabuae.com

APPROVED BY CLIENT

DE TECH
CONTRACTING

APPROVED BY: DESIGNER

ASIF LATIF

APPROVED BY:PRODUCTION MANAGER

MR. SALIM

DWG. NO.

-

FLOOR : Nos.

G.F ONLY

DRAWING TITLE :

PREFAB SITE OFFICE

SHEET CONTENTS

DRAINAGE LAYOUT

AREA


198 SQM

DATE:

08-08-2022

CONSULTANT:

REV:	DESCRIPTION	DATE
Location	SCALE : NTS	SHEET NO:
DRAWN BY	PAPER SIZE : A4	01

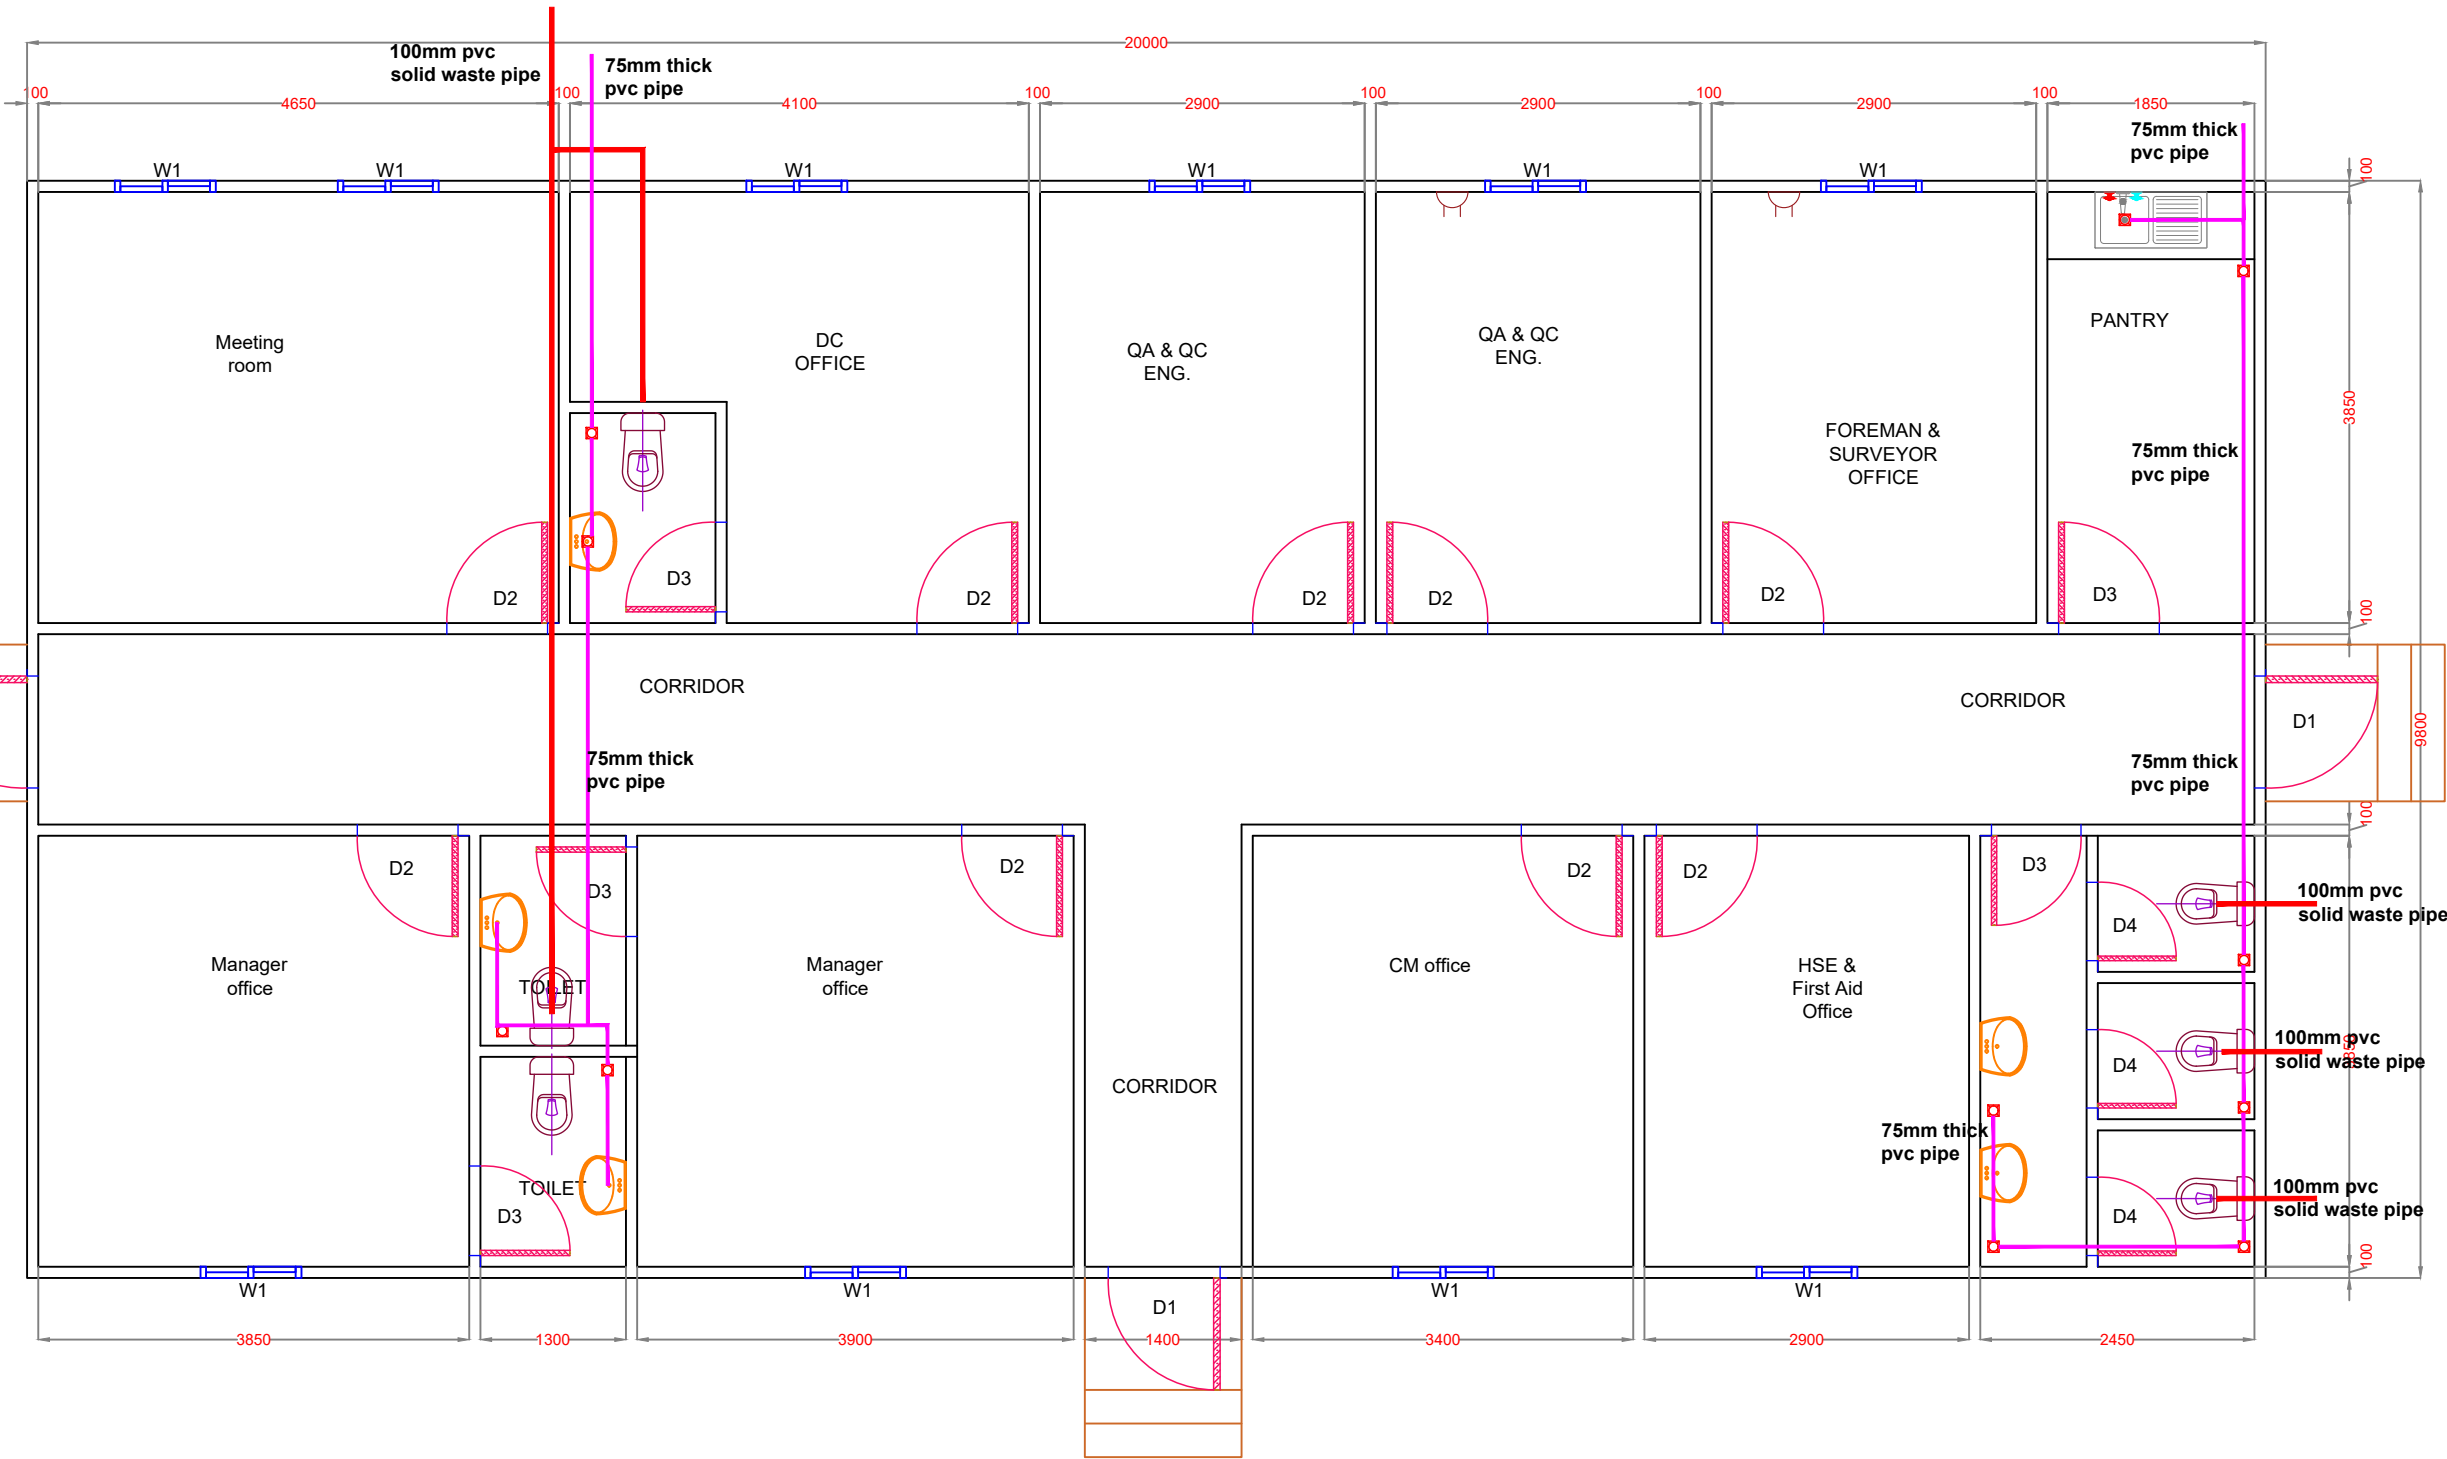

DRAINAGE
LAYOUT

