




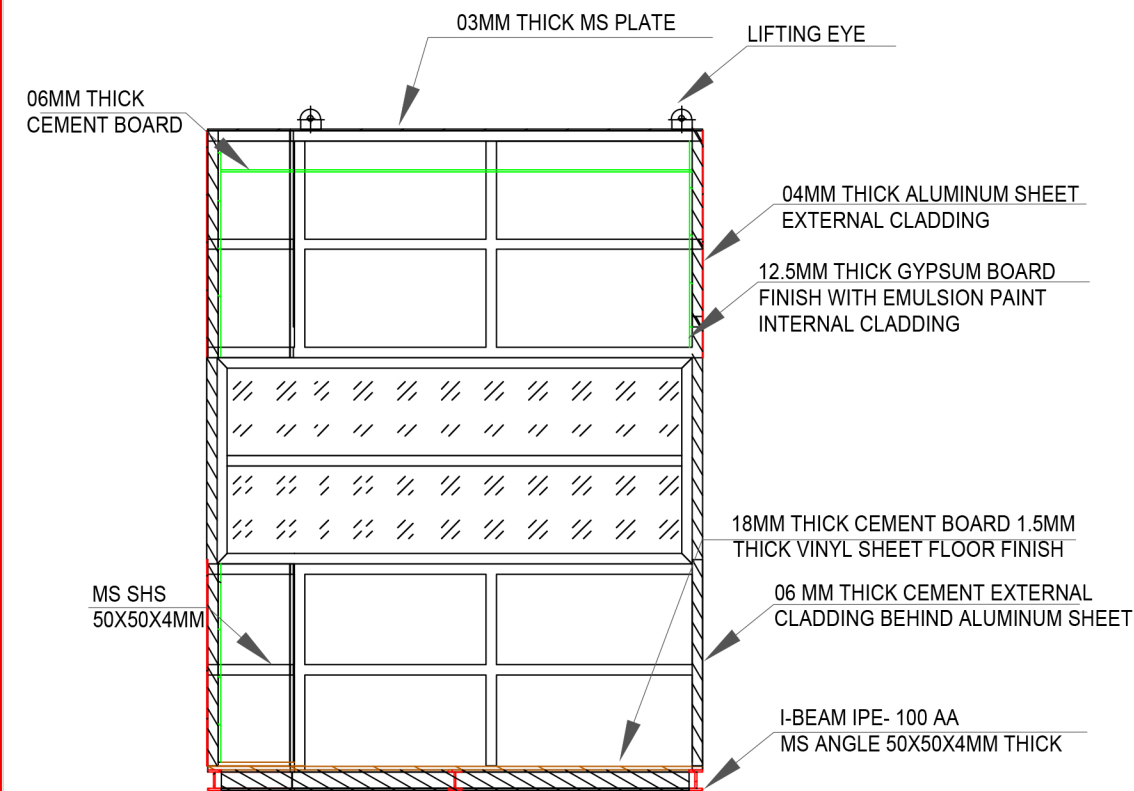


SECTION DETAIL

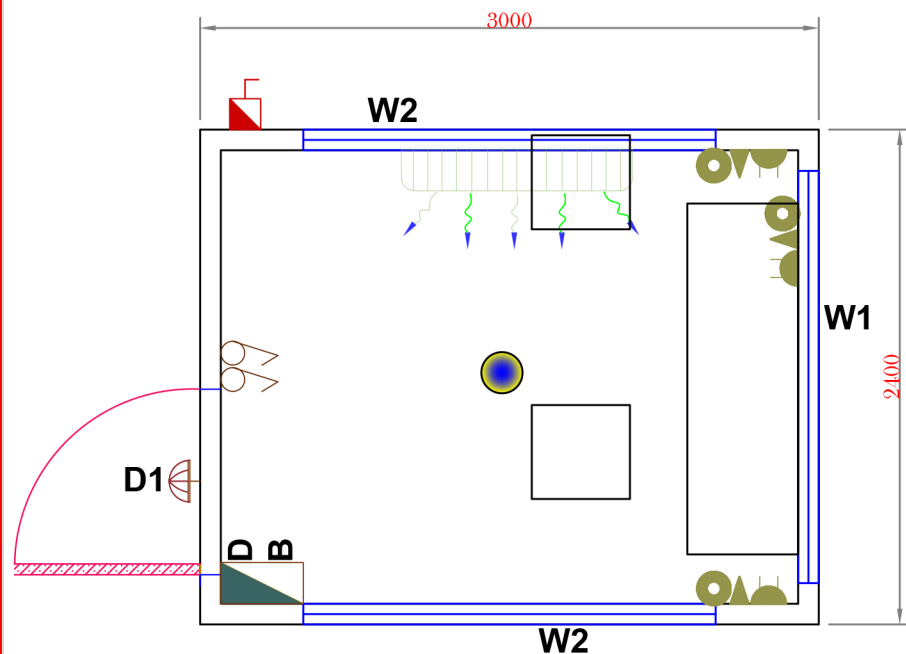


FLOOR LAYOUT

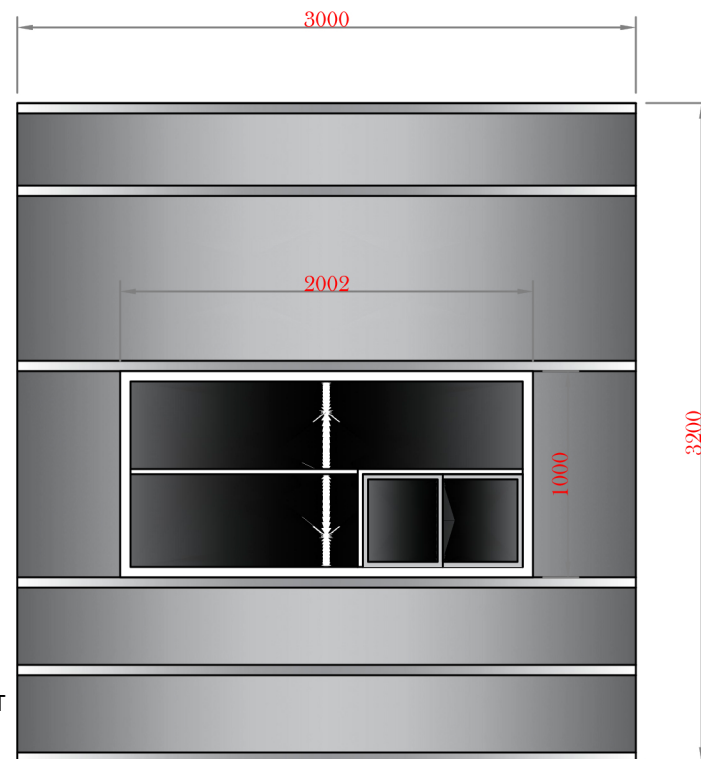


LEFT ELEVATION

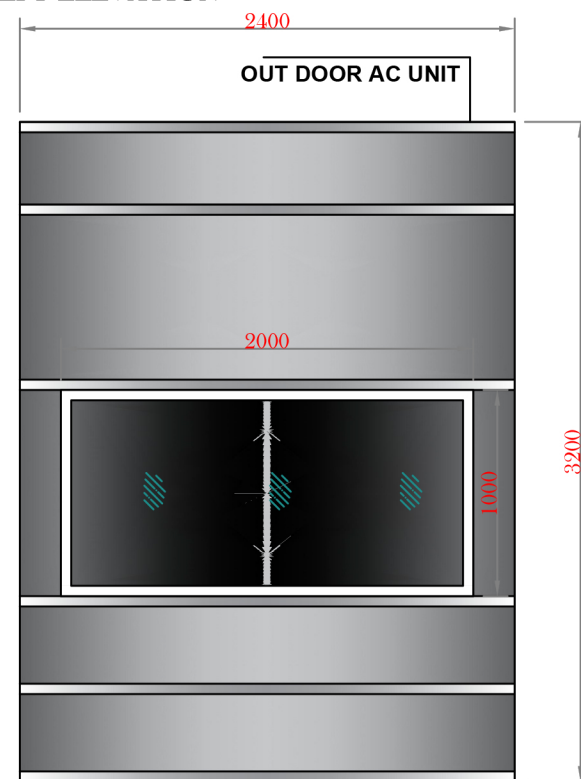

FRONT ELEVATION

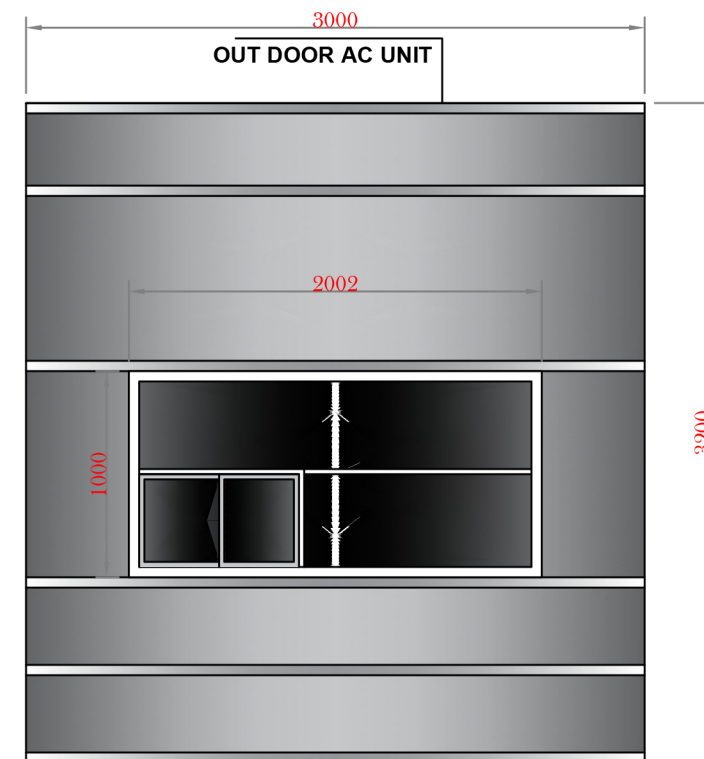

RIGHT ELEVATION

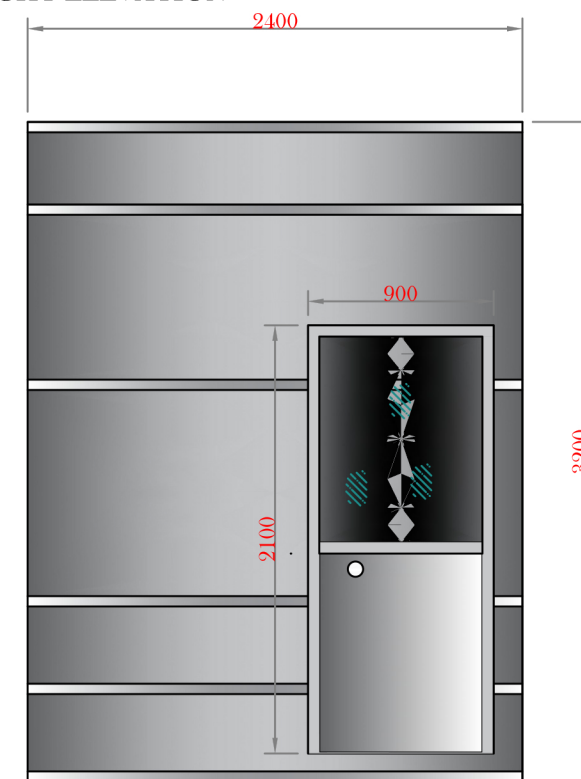

BACK ELEVATION

LEGEND

ELECTRICAL

	13A SWITCH SOCKET(Double)
	15A SWITCH SOCKET
	WATER HEATER 12 gl.
	ISOLATOR-32A (IP 65,TP/SP)
	DISTRIBUTION BOARD
	ONE GANG ONE WAY SWITCH
	DOUBLE POLE SWITCH NEON-20A
	DATA POINT (provision only)
	TEL. POINT (provision only)
	13A SWITCH SOCKET
	REF.FLUORESCENT FITTING-4x18w (60x60)
	FLUORESCENT FITTING-1x36w
	FLUORESCENT FITTING-2x36w
	BULKHEAD LAMP
	EXHAUST FAN (6")

PLUMBING

	W/C EUROPEAN		KITCHEN SINK
	W/C ASIAN		WATER HEATER
	WASH BASIN		FLOOR TRAP
	URINAL		WATER TAP
	SHOWER TRAY		

PREFAB
Space Box Prefab Houses Ind L.L.C
Tel: 06-5214409 Fax: 06-5214409
Mob: 050-4738366
Email: arif@prefabuae.com
www.prefabuae.com

APPROVED BY CLIENT

FARAH

APPROVED BY: DESIGNER

ASIF LATIF

APPROVED BY: PRODUCTION MANAGER

MR. SALIM

DWG. NO.

FLOOR : Nos.

G.F ONLY

DRAWING TITLE :

SECURITY CABIN

SHEET CONTENTS

FLOOR,ELEVATION,SECTION

AREA

DATE:

08-12-2021

PROJECT PHASE :

REV:	DESCRIPTION	DATE
Location	SCALE : NTS	SHEET NO:
DRAWN BY: AL	PAPER SIZE : A3	01